



PREFAB E

Innovation space

GJU
 الجامعة الألمانية الأردنية
 German Jordanian University
 12/11/2023


KEY PLAN



Client




Consultant
 German Jordanian
 University
 AMMAN - JORDAN

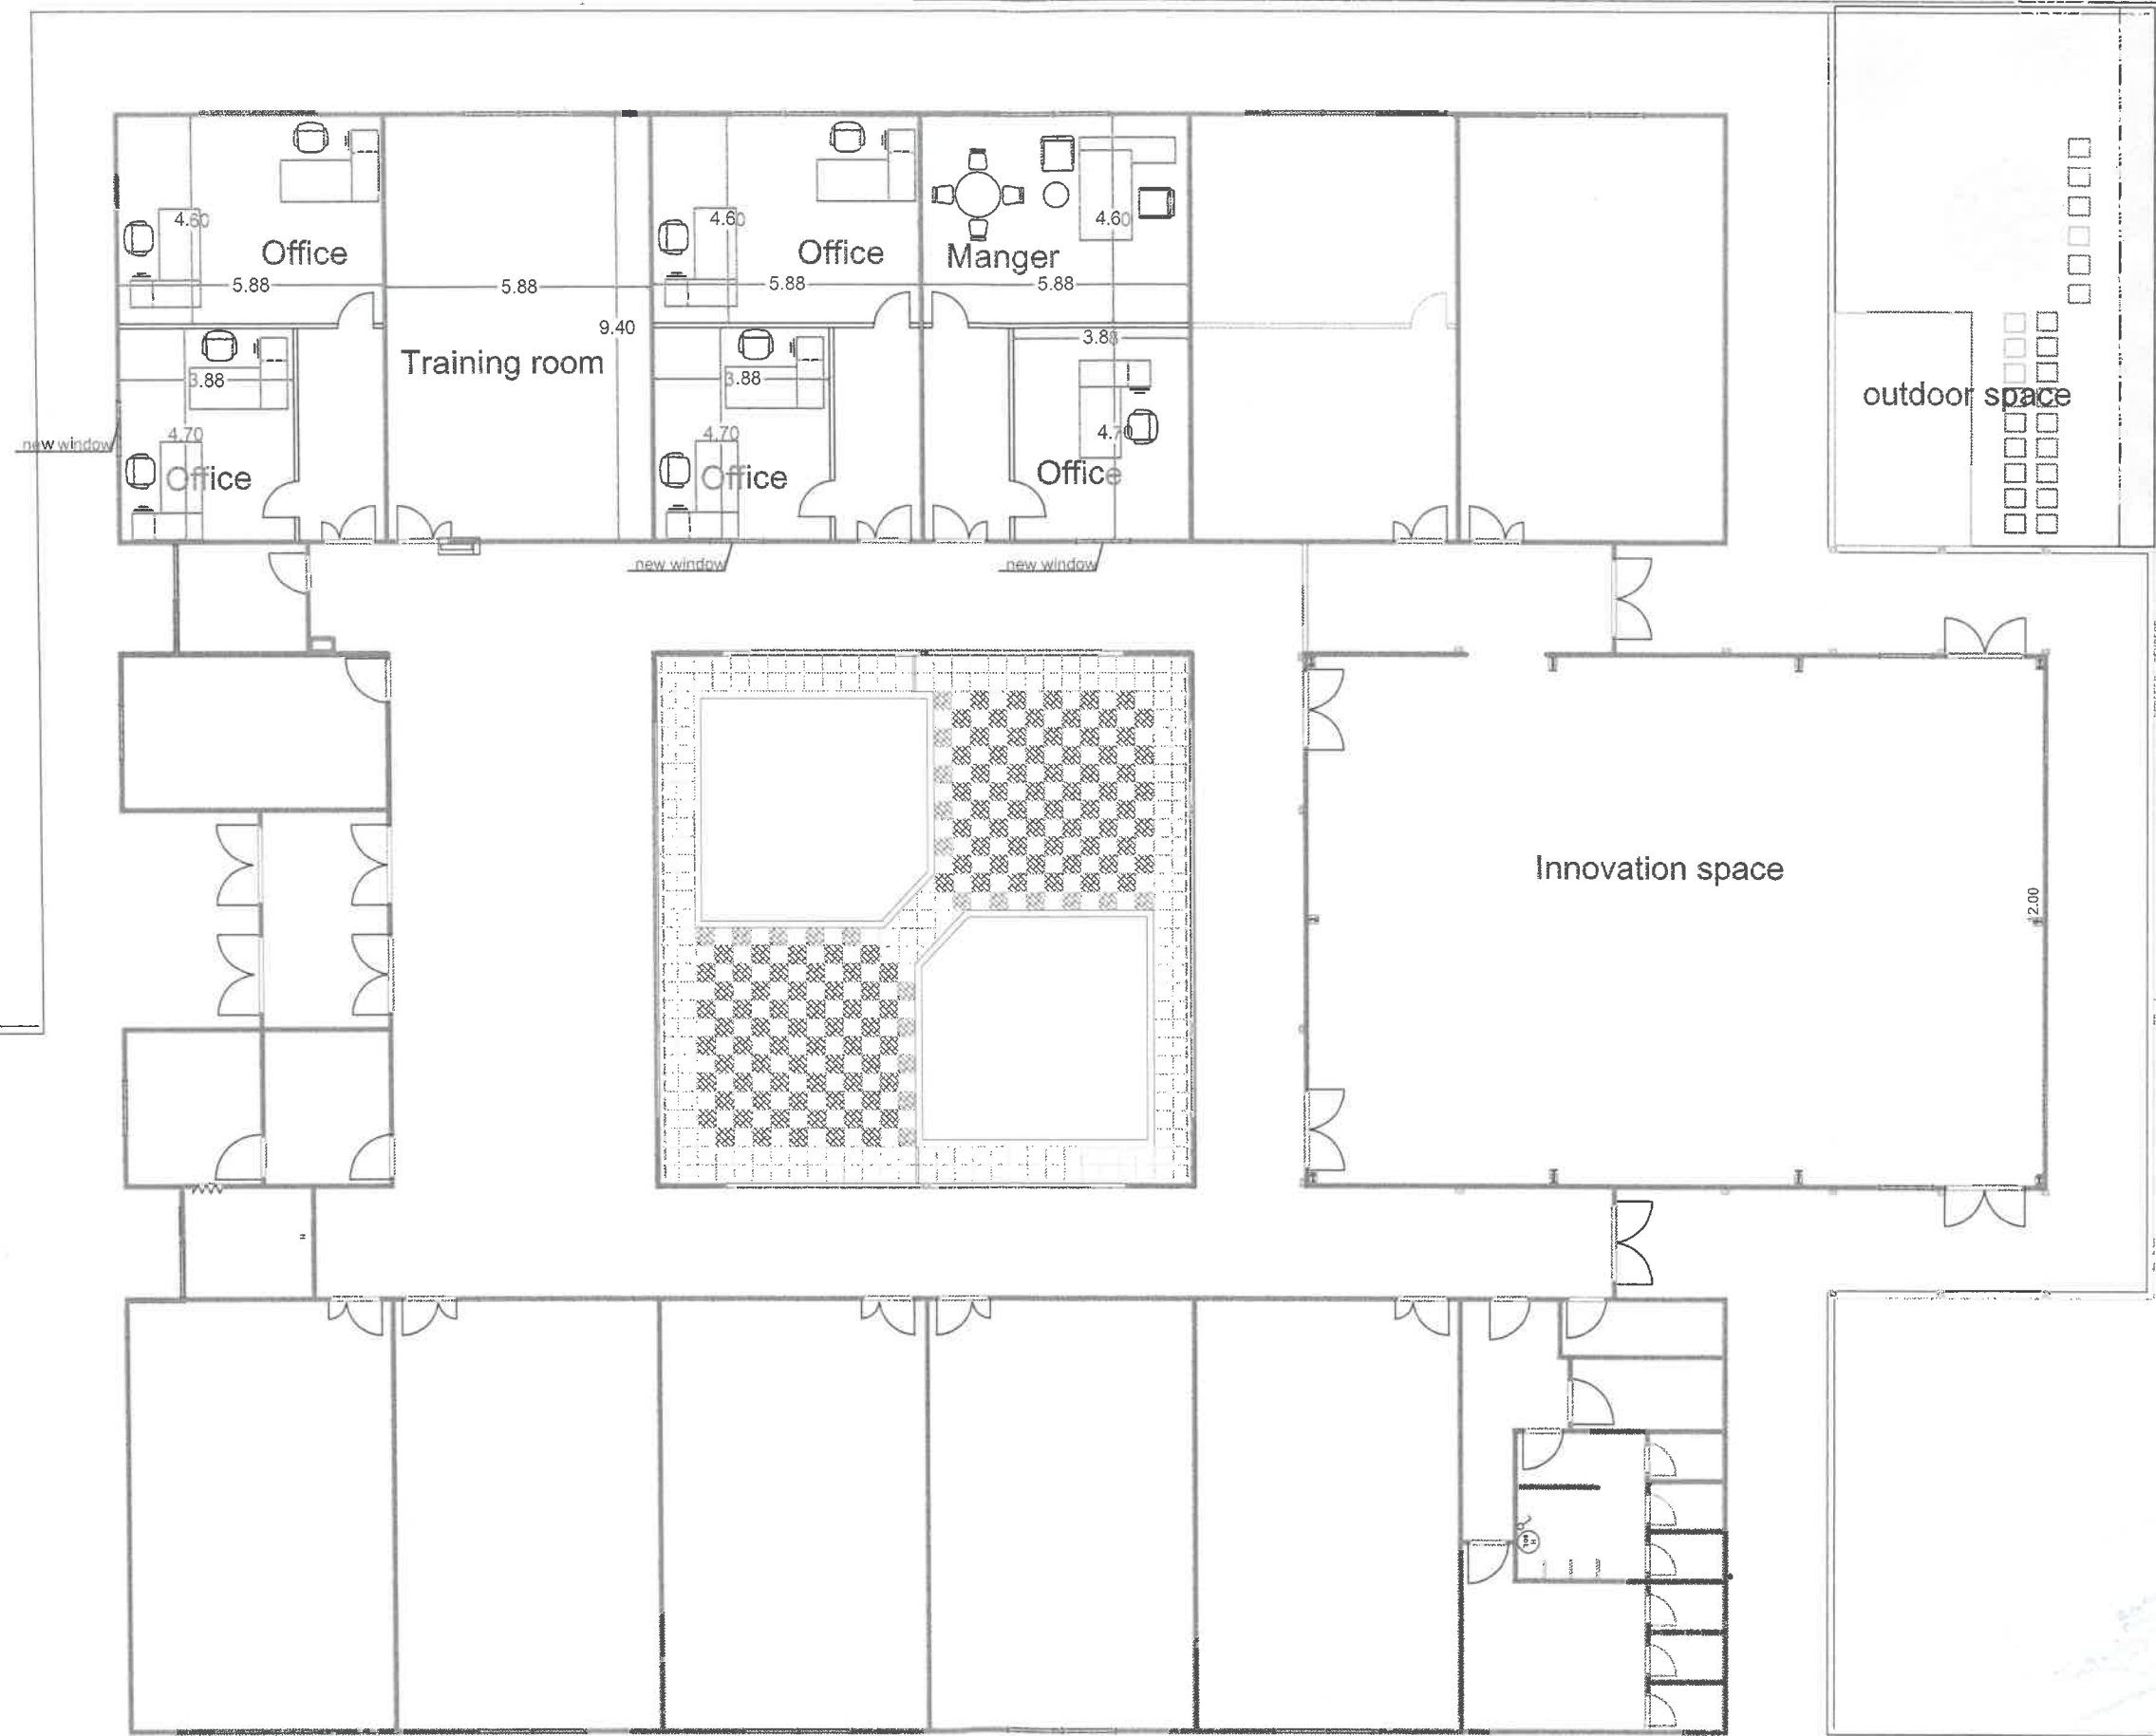



PRODUCED BY AN AUTODESK STUDENT VERSION

PRODUCED BY AN AUTODESK STUDENT VERSION
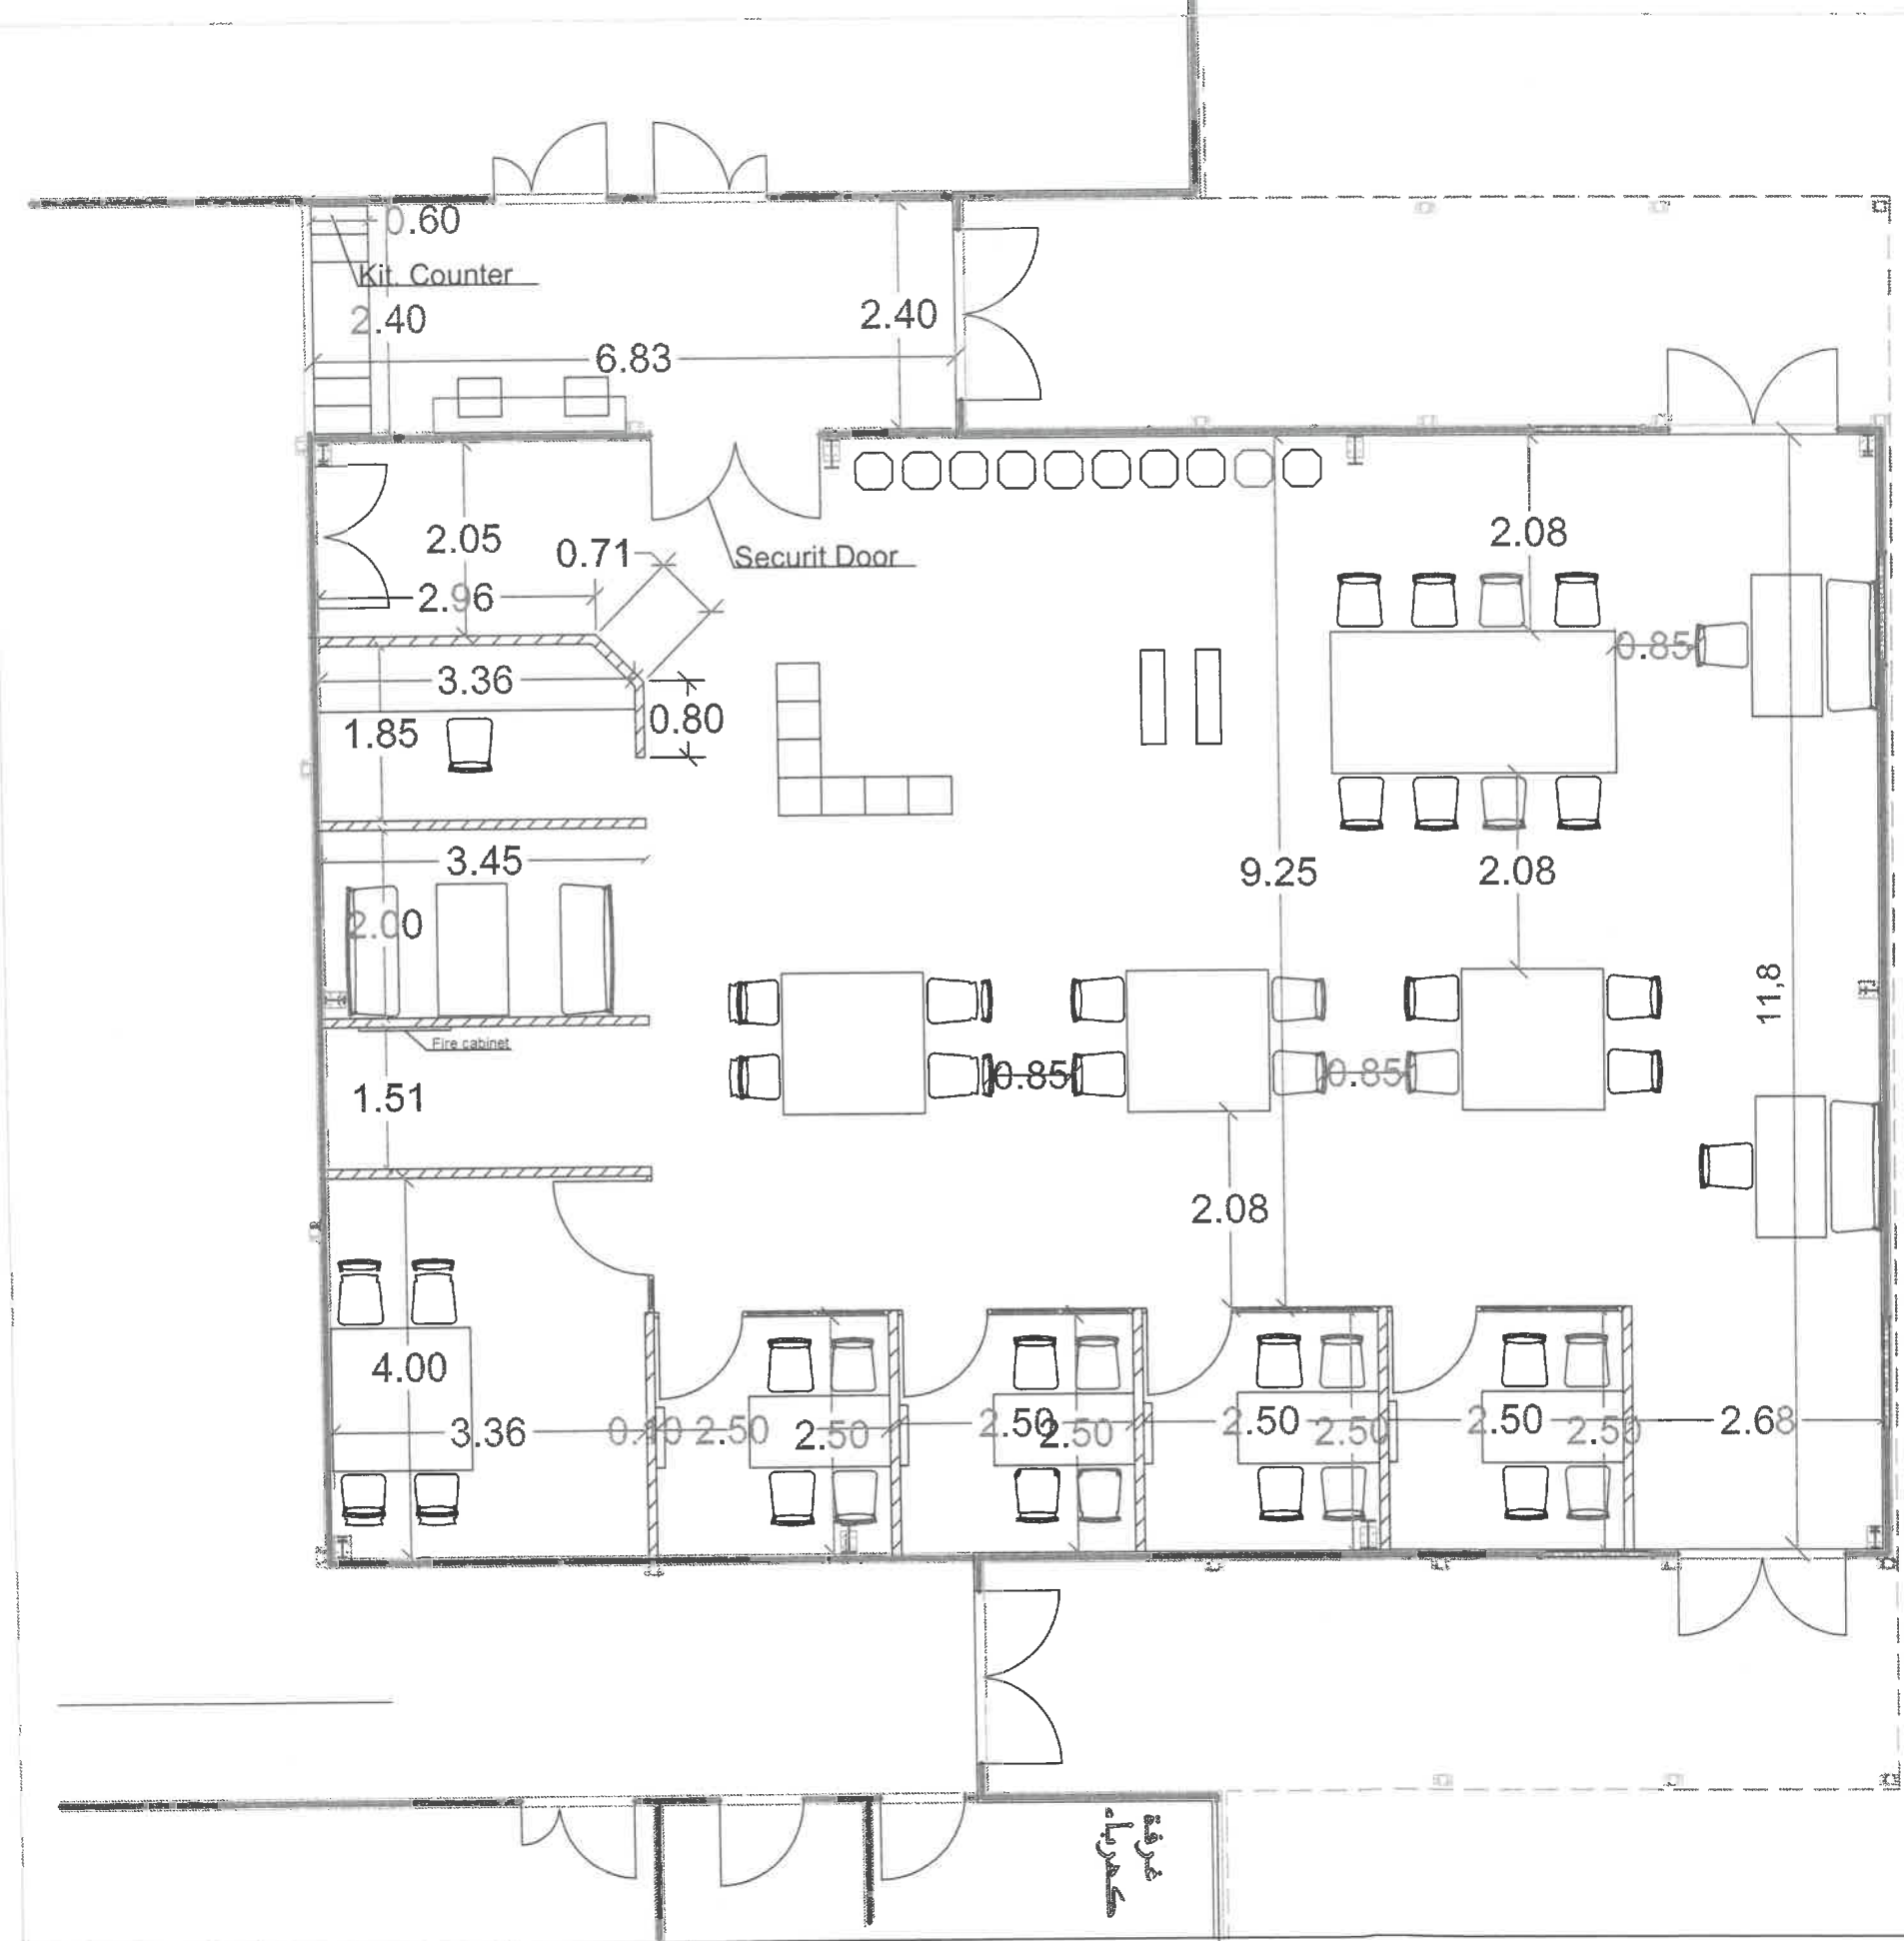
<p>KEY PLAN</p> 	<p>Client</p>  <p>German Jordanian University AMMAN - JORDAN</p>	<p>Consultant</p> <p>German Jordanian University AMMAN - JORDAN</p>	<p>PREFAB E Gypsum board Partitions</p>	<p>Scale N.T.S</p>	<p>A01</p>
---	---	---	---	------------------------	------------



LEGEND :


-  PROPOSED PARTITION
-  PROPOSED GLASS PARTITION







Client
GJU
 الجامعة الألمانية الأردنية
 German Jordanian University
 AMMAN - JORDAN

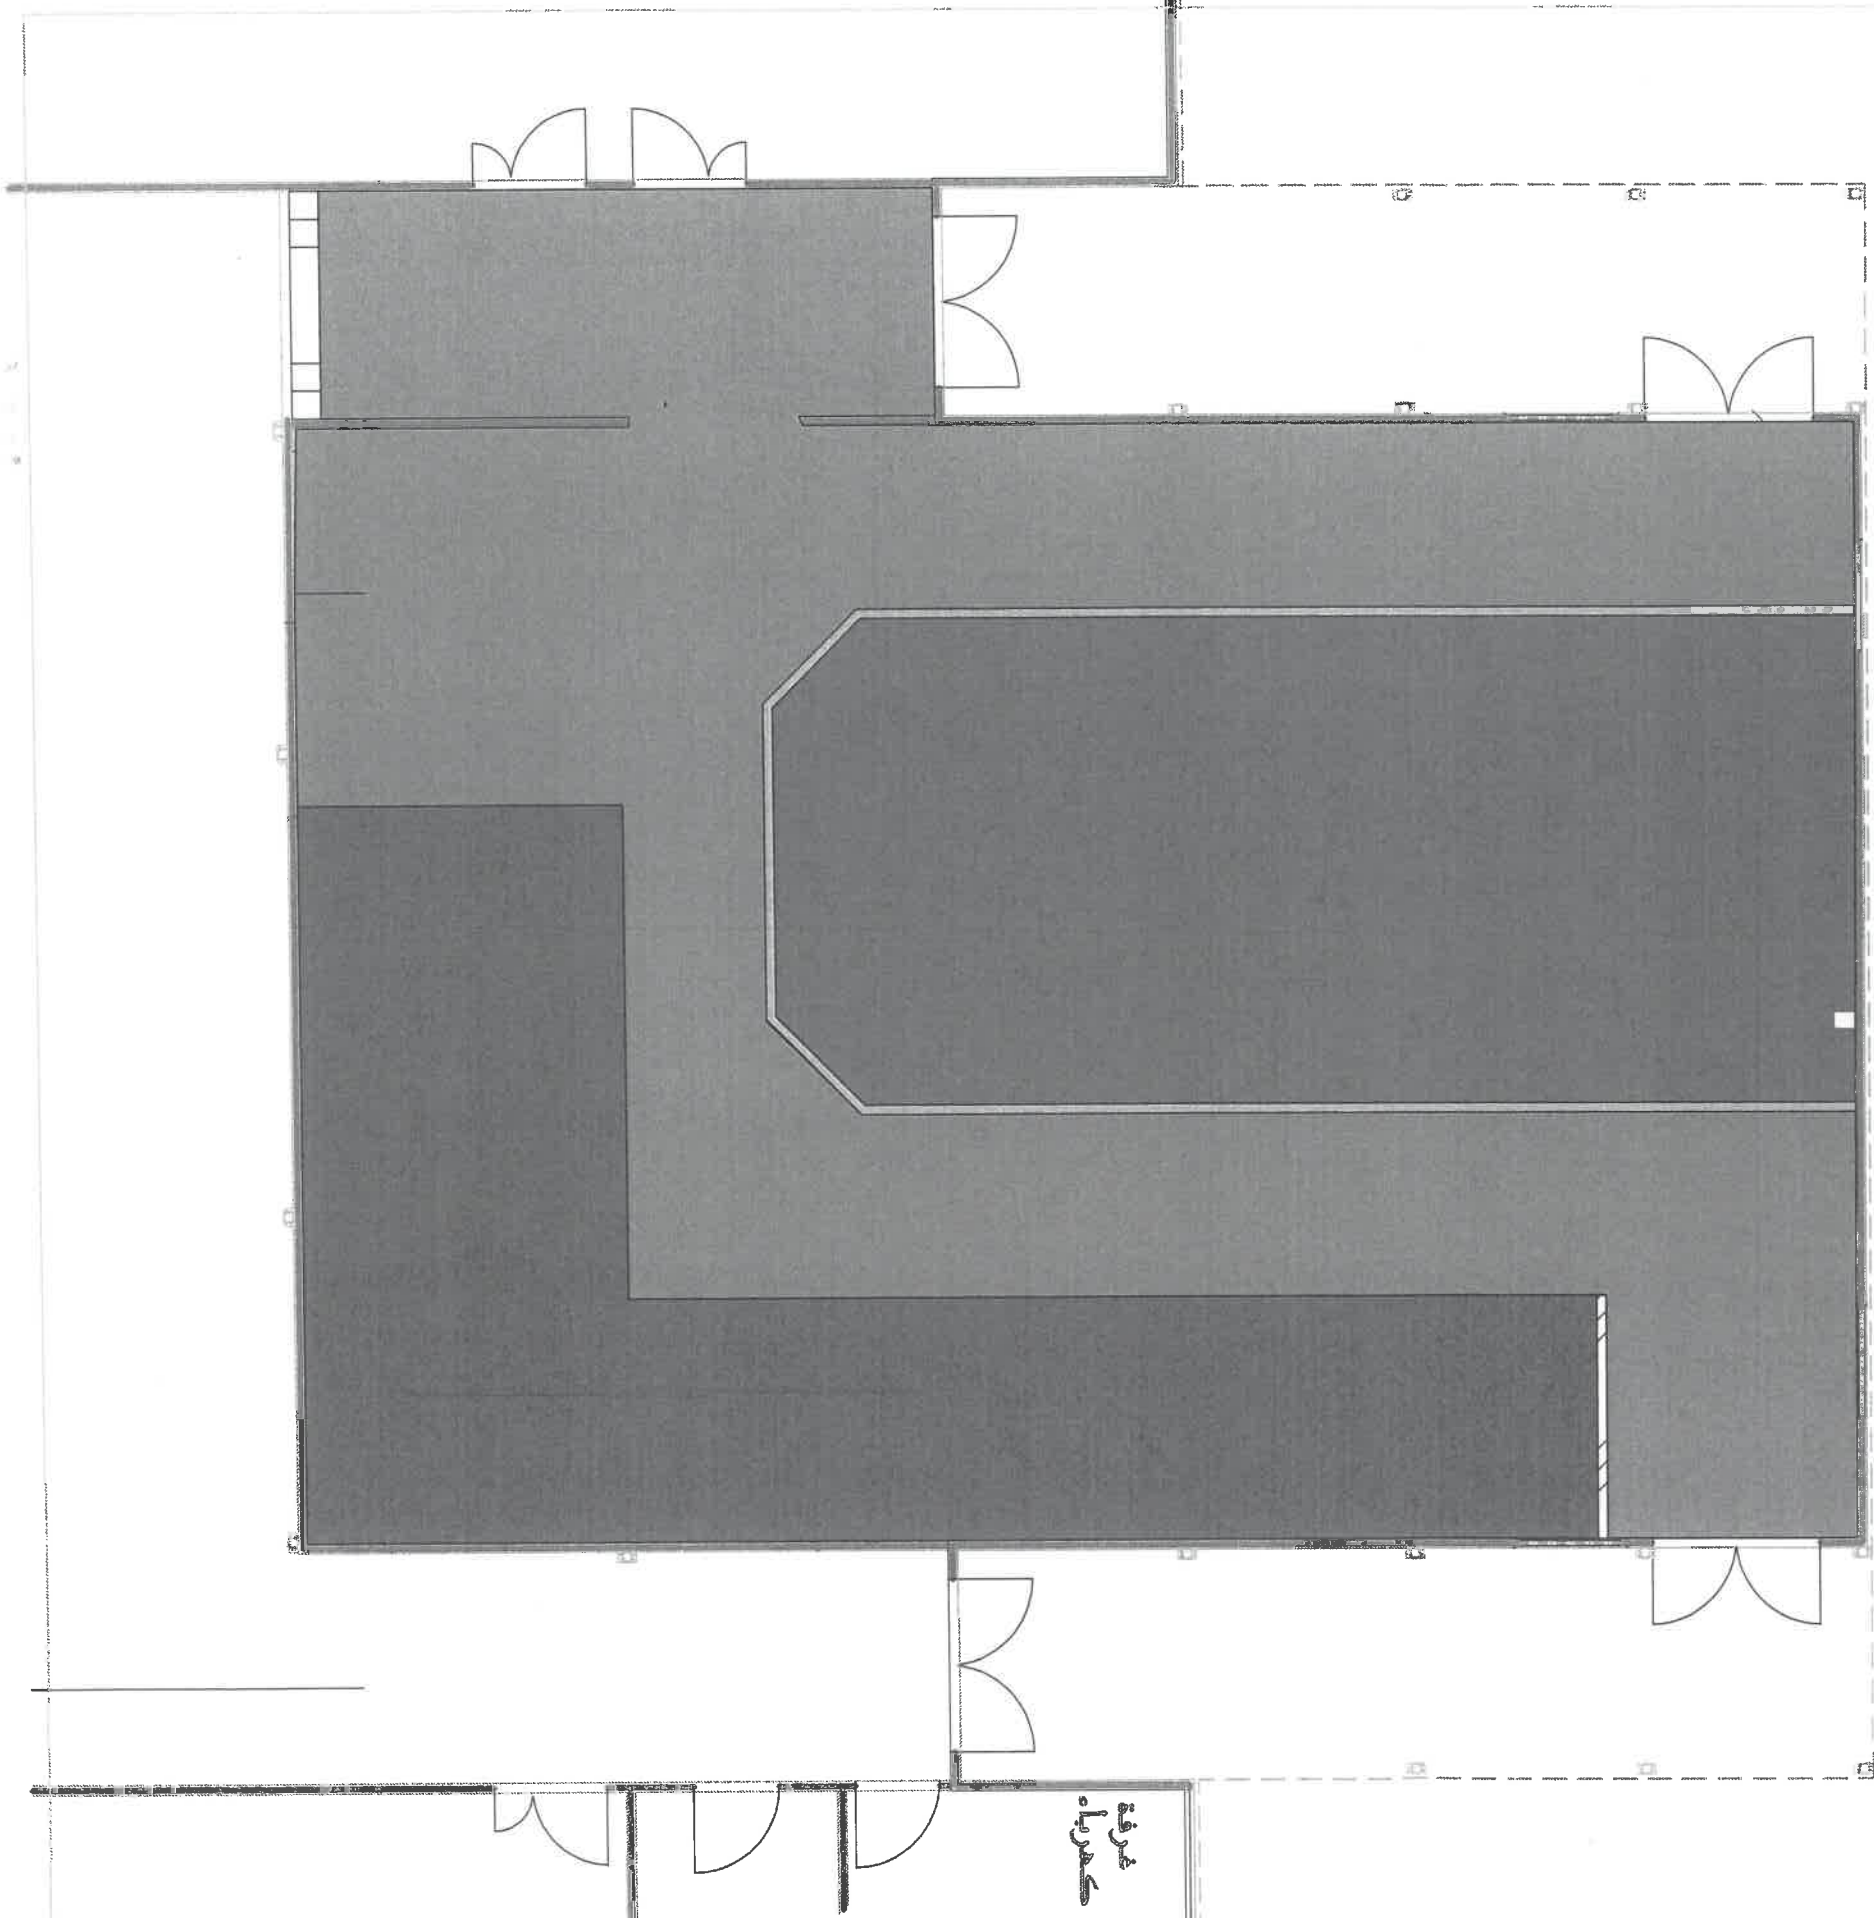Consultant
 German Jordanian University
 AMMAN - JORDAN

PREFAB E Innovation space	Scale N.T.S	A02
------------------------------	----------------	-----




FLOORS

	61	M2
	3	M2
	53	M2
	96	M2

غرفة
مكاتب


KEY PLAN 	Client  الجامعة الألمانية الأردنية German Jordanian University	Consultant German Jordanian University AMMAN - JORDAN	PREFAB E Innovation space	Scale N.T.S	A03
---	--	--	------------------------------	----------------	-----

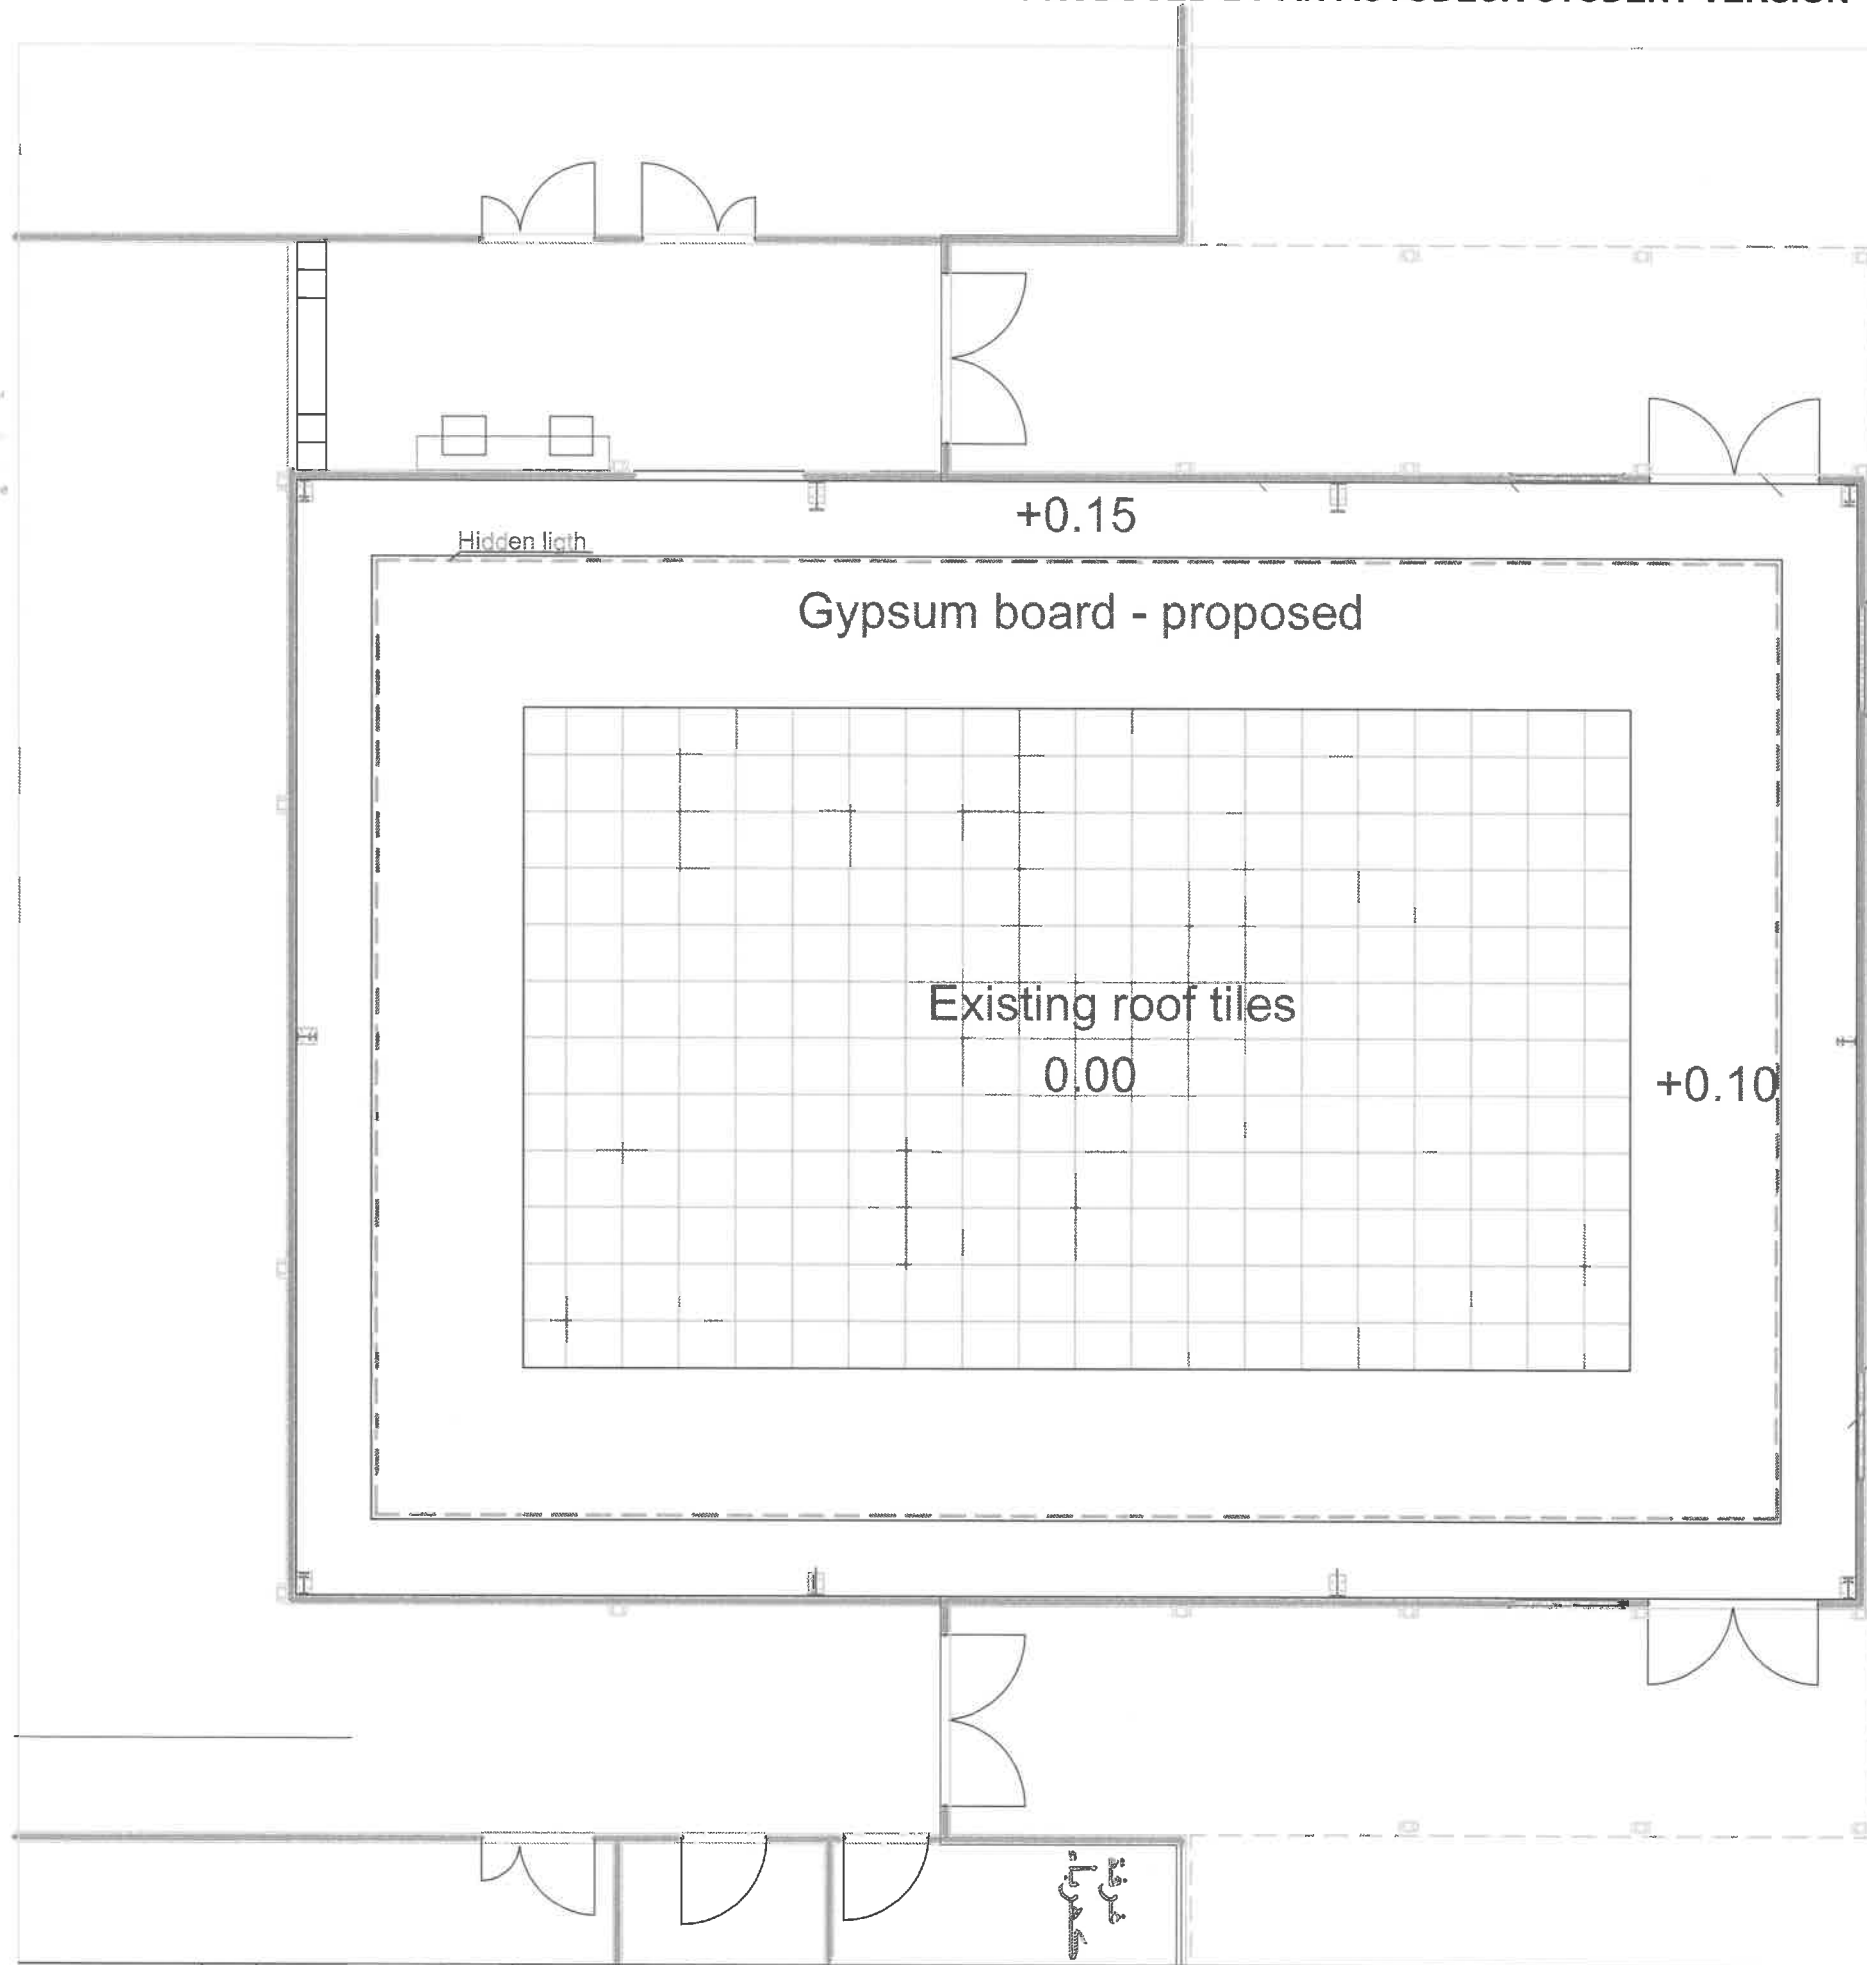

Client
GJU
 الجامعة الألمانية الأردنية
 German Jordanian University

Consultant
 German Jordanian
 University
 AMMAN - JORDAN

PREFAB E Innovation space	Scale N.T.S	A04
------------------------------	----------------	-----

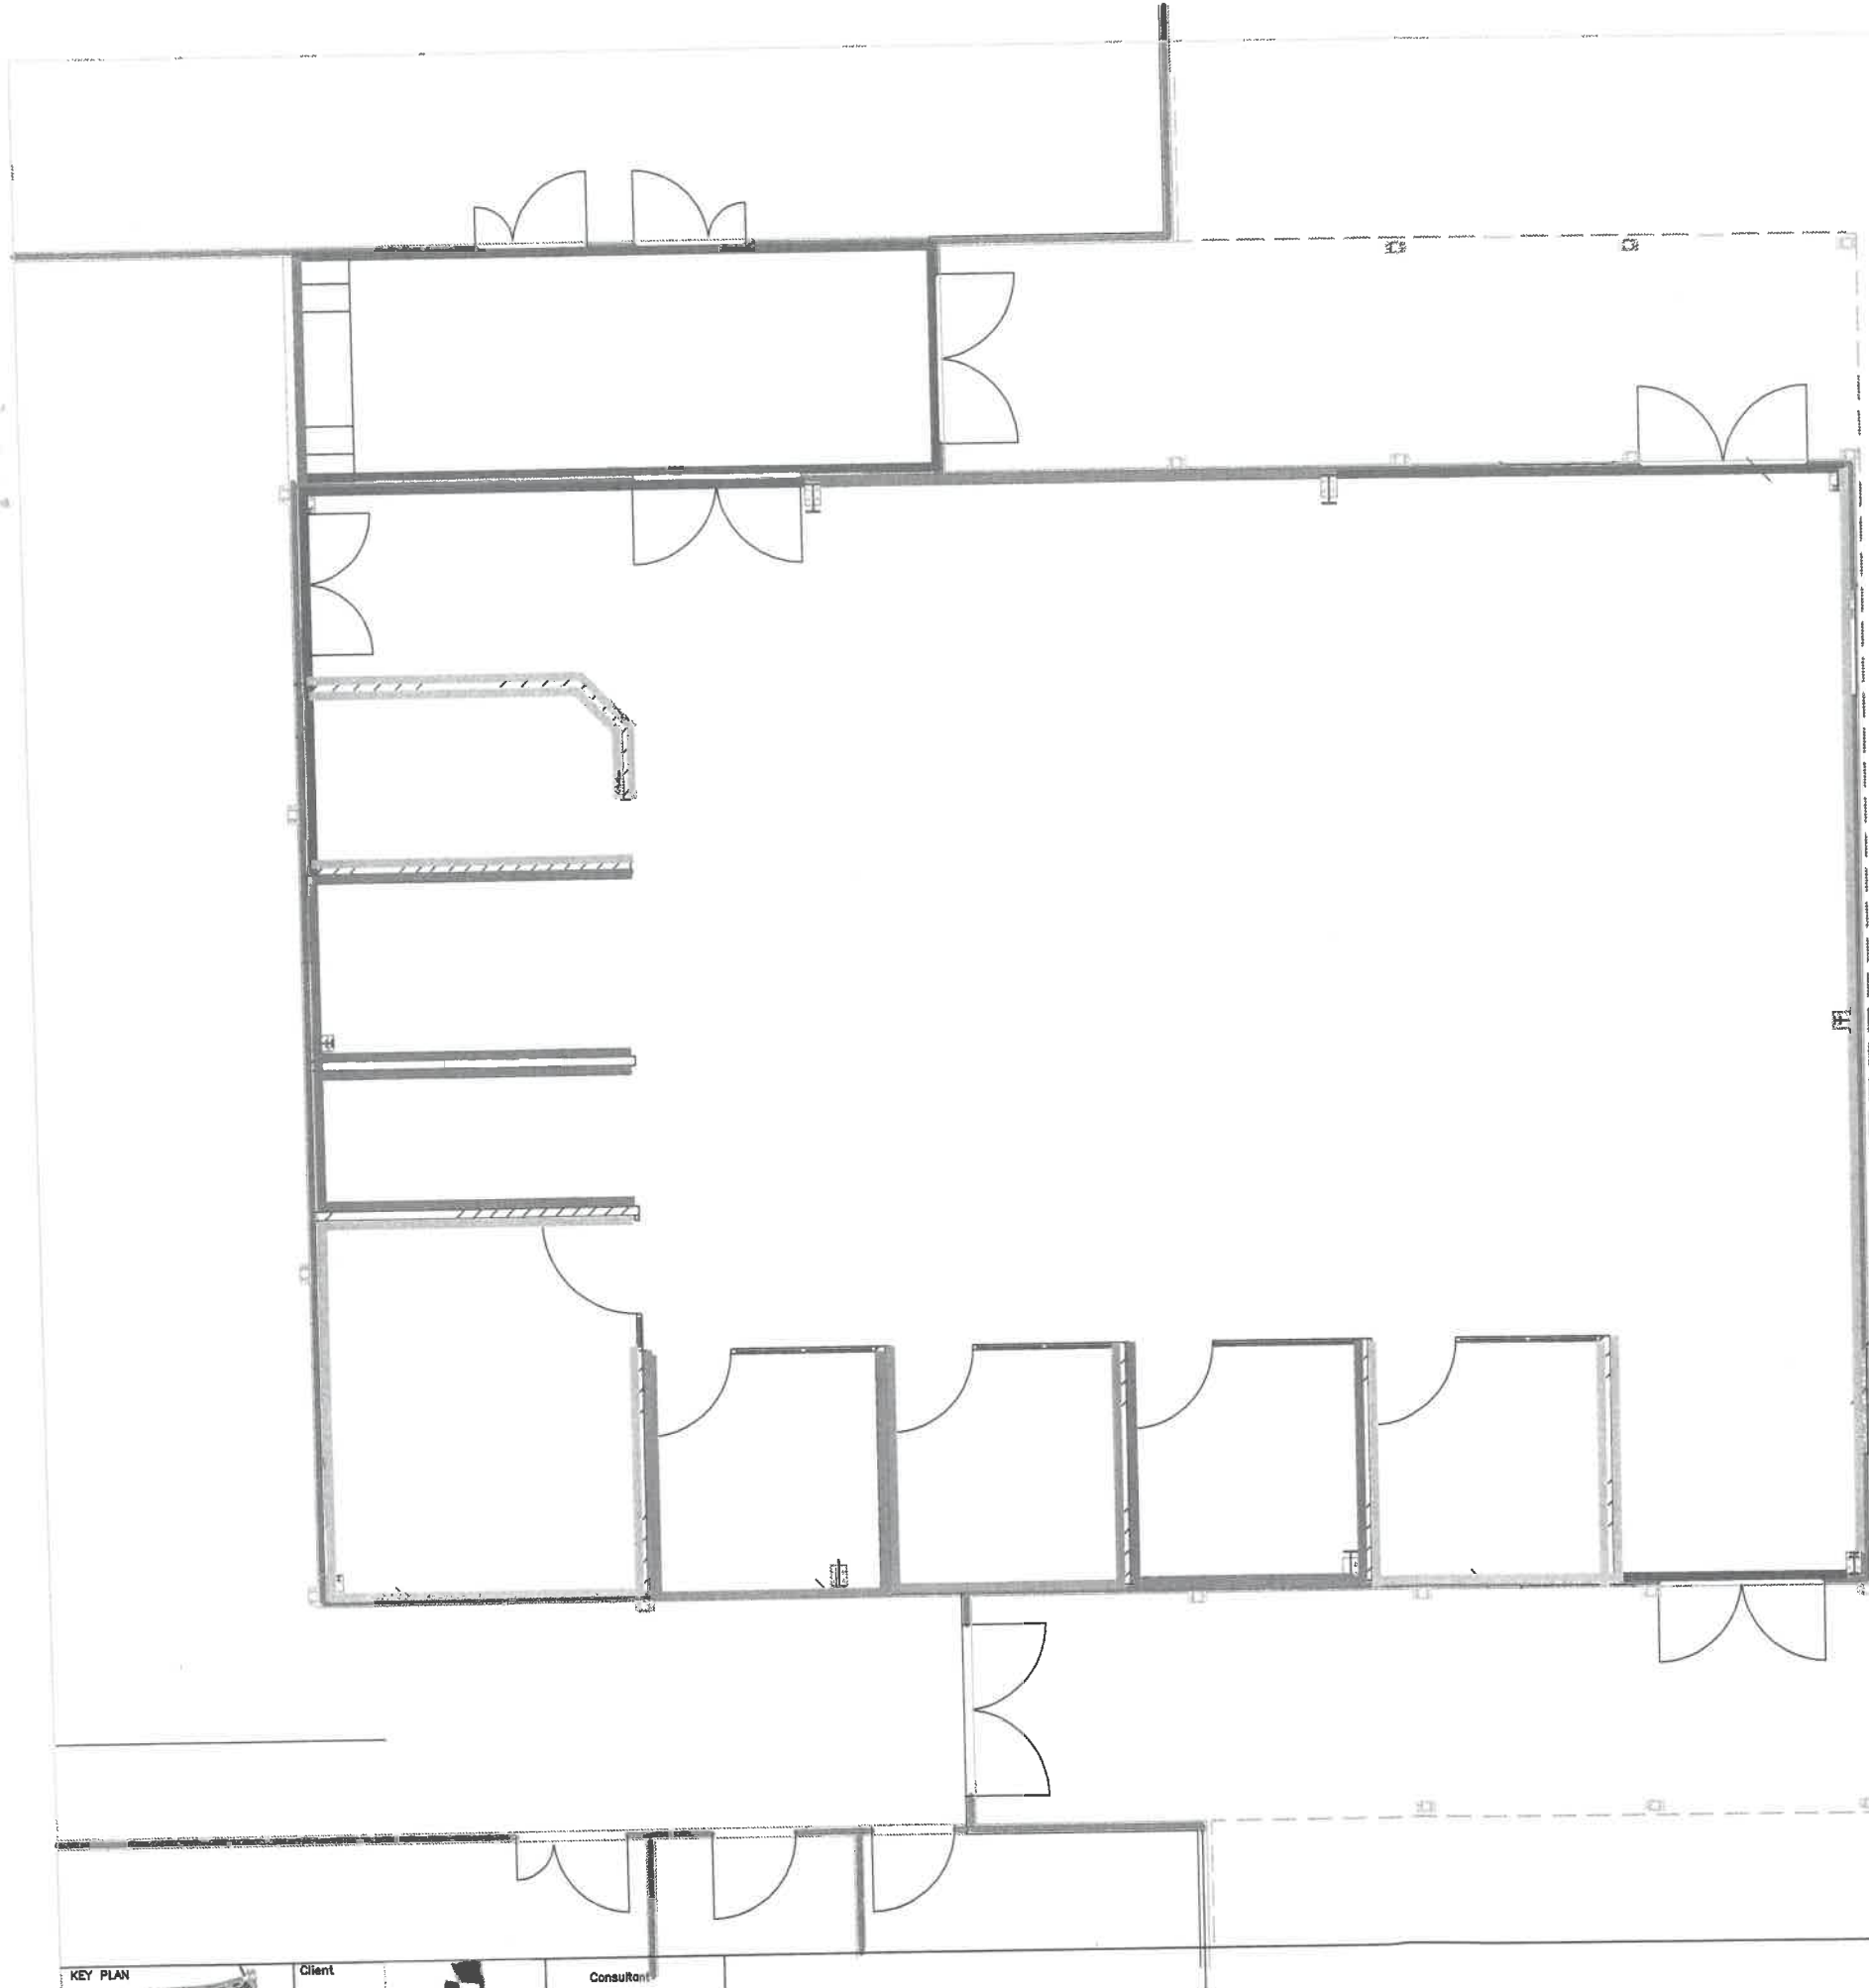

Walls coverings

(White)



جامعة عمان الأردنية
 Faculty of Architecture
 Department of Architecture
 2023

KEY PLAN


Client

Client
 German Jordanian University
 AMMAN - JORDAN


Consultant

Consultant
 AMMAN - JORDAN

PREFAB E Innovation space	Scale N.T.S	A05
------------------------------	----------------	-----

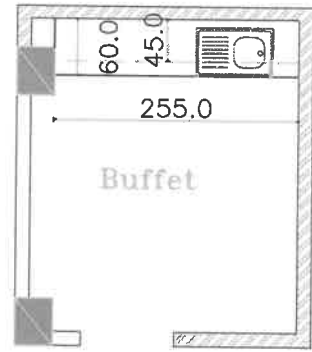

Sport Hall VIP Kitchen

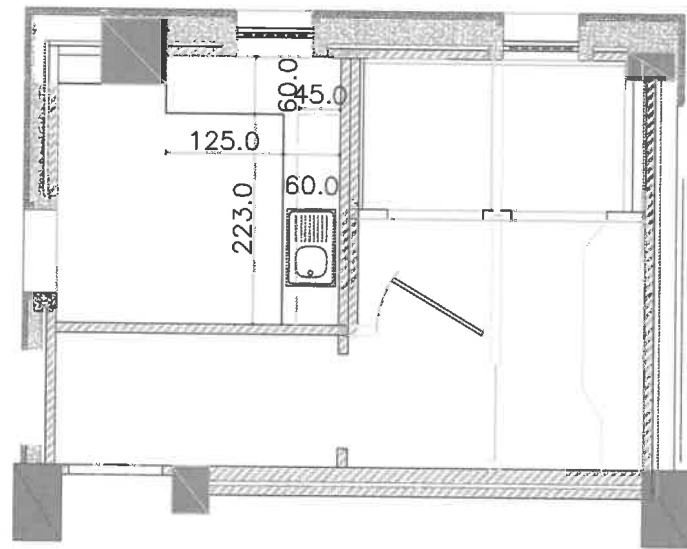

Deanship of Student Affairs Kitchen




Client

 الجامعة الألمانية الأردنية
 German Jordanian University
 AMMAN - JORDAN

Consultant
 German Jordanian
 University
 AMMAN - JORDAN

Sport Hall Kitchens	Scale N.T.S	A06
---------------------	----------------	-----

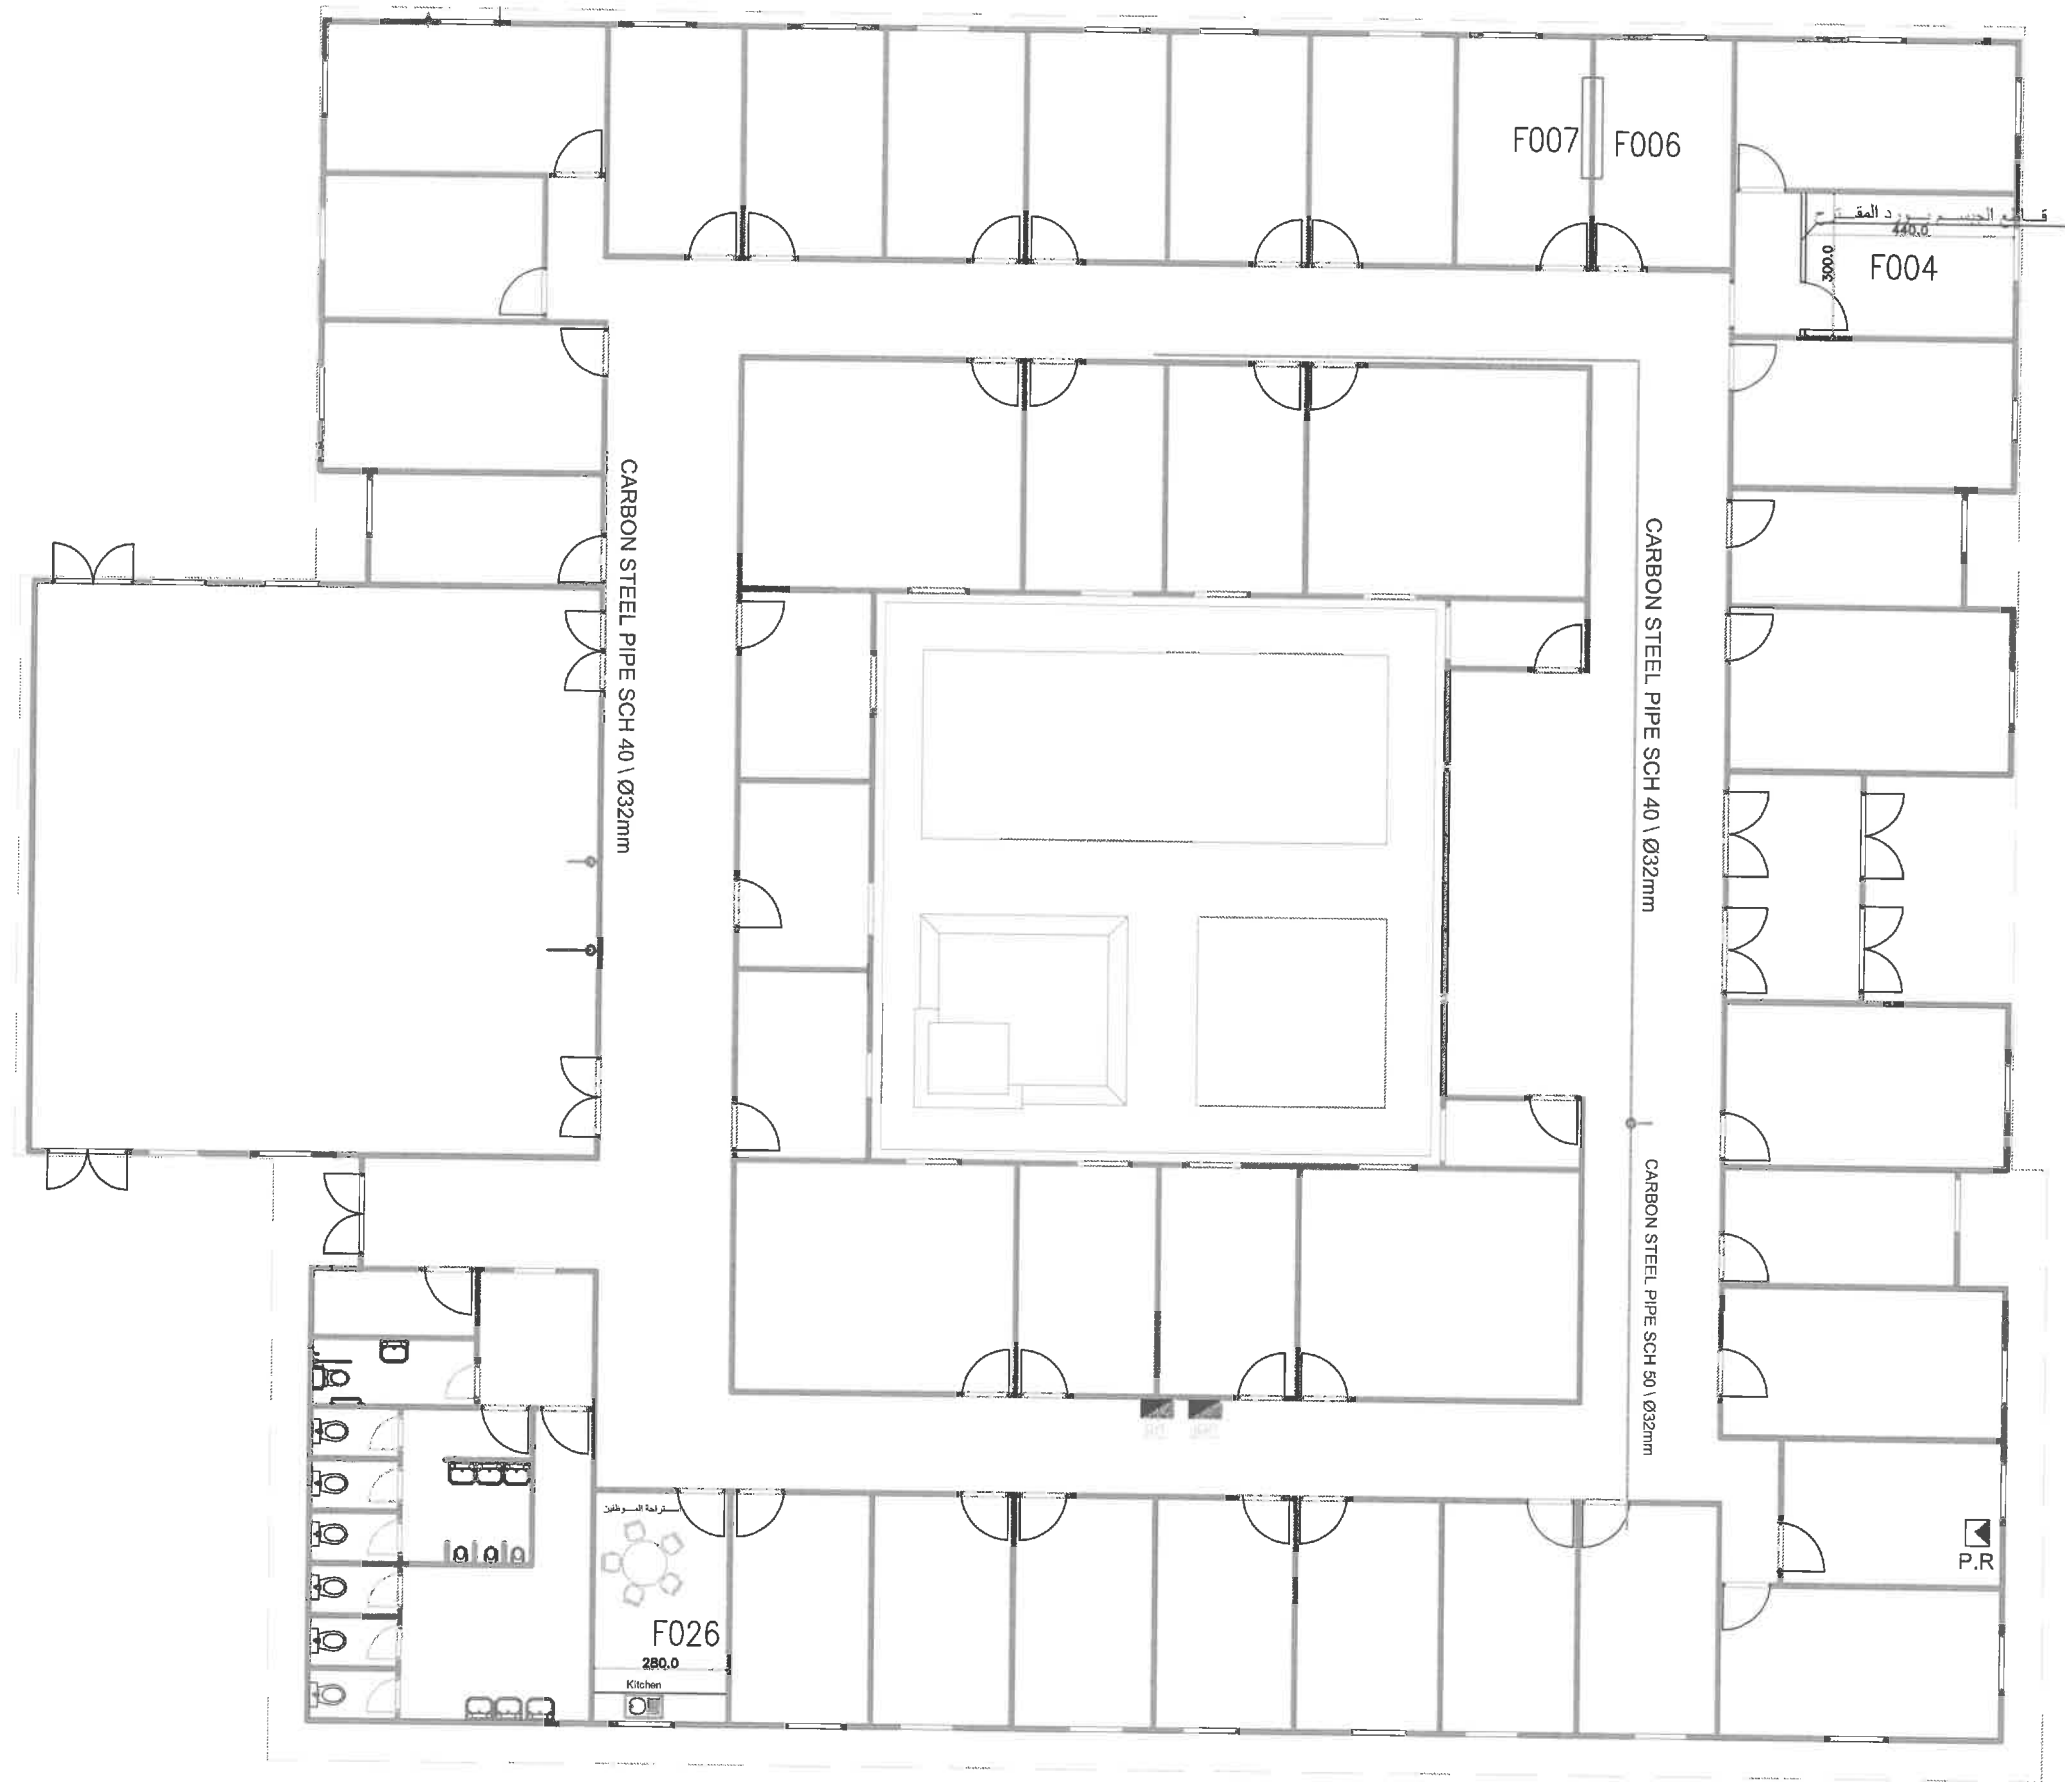

Client
GJU
 الجامعة الألمانية الأردنية
 German Jordanian University

Consultant
 German Jordanian University
 AMMAN - JORDAN

Prefab F

Scale
 N.T.S

A07




Client
 GJU
 الجامعة الألمانية الأردنية
 German Jordanian University
 AMMAN - JORDAN

Consultant
 German Jordanian
 University
 AMMAN - JORDAN

PREFAB E
 Ventilation System

Scale
 N.T.S

M01

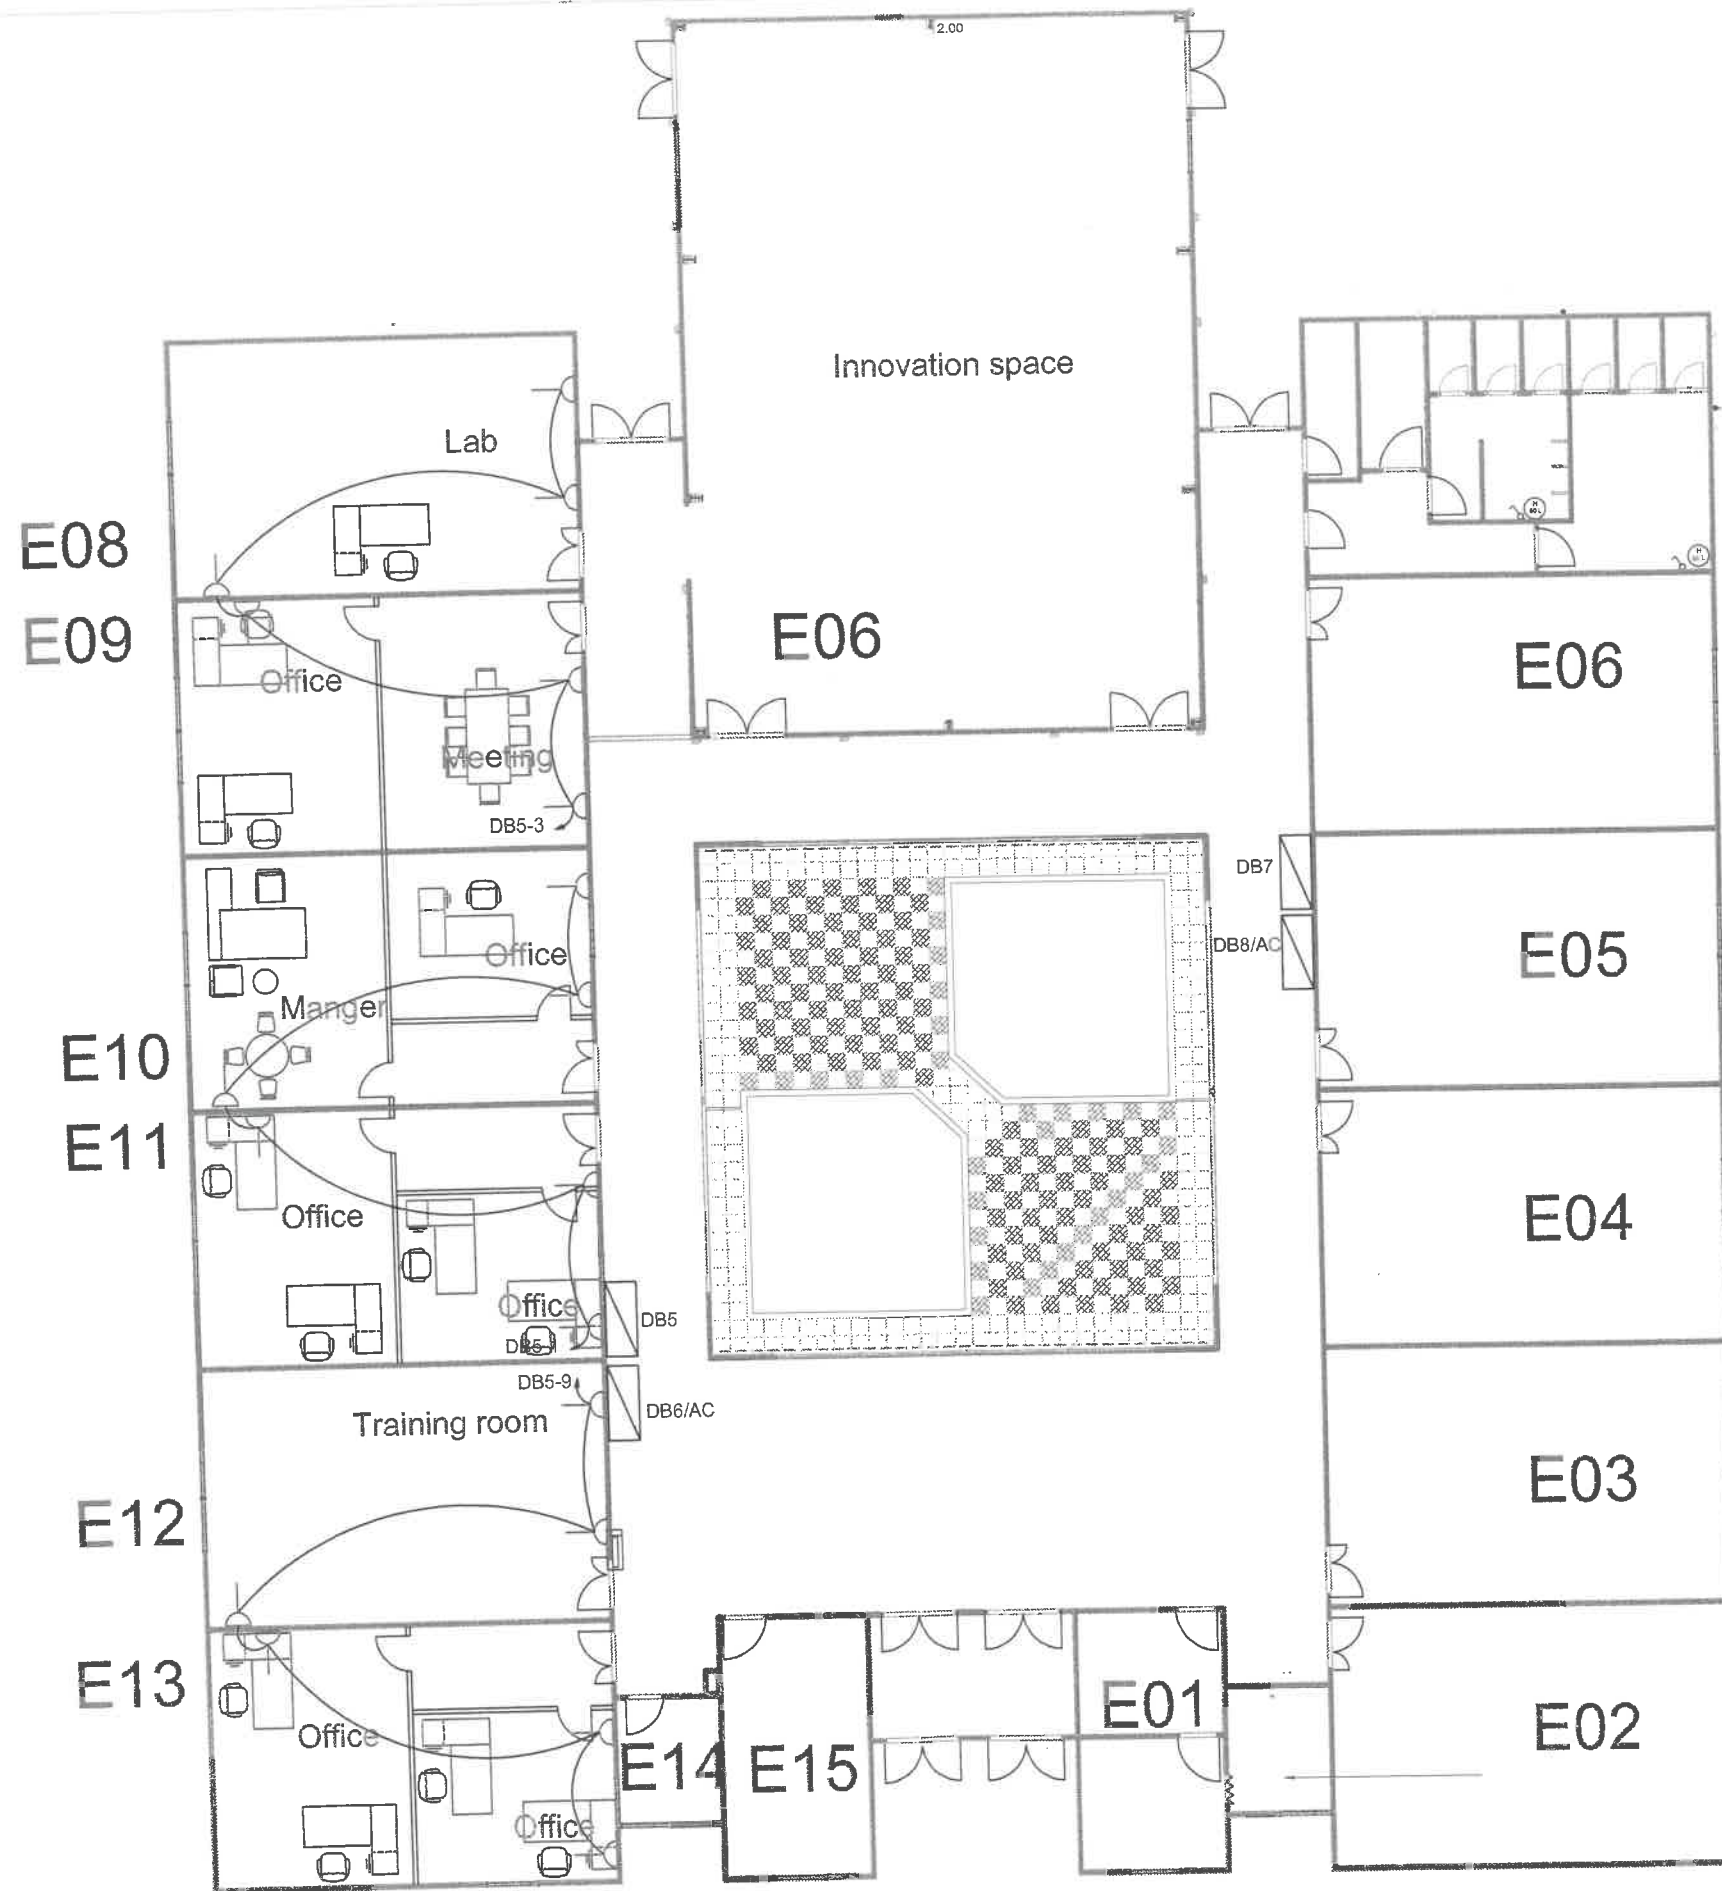

As-Built Drawing socket outlets

PRODUCED BY AN AUTODESK STUDENT VERSION


PRODUCED BY AN AUTODESK STUDENT VERSION

KEY PLAN 

Client  German Jordanian University
 الجامعة الألمانية الأردنية
 German Jordanian University
 AMMAN - JORDAN

Consultant


PREFAB E	Scale N.T.S	E01
----------	----------------	-----

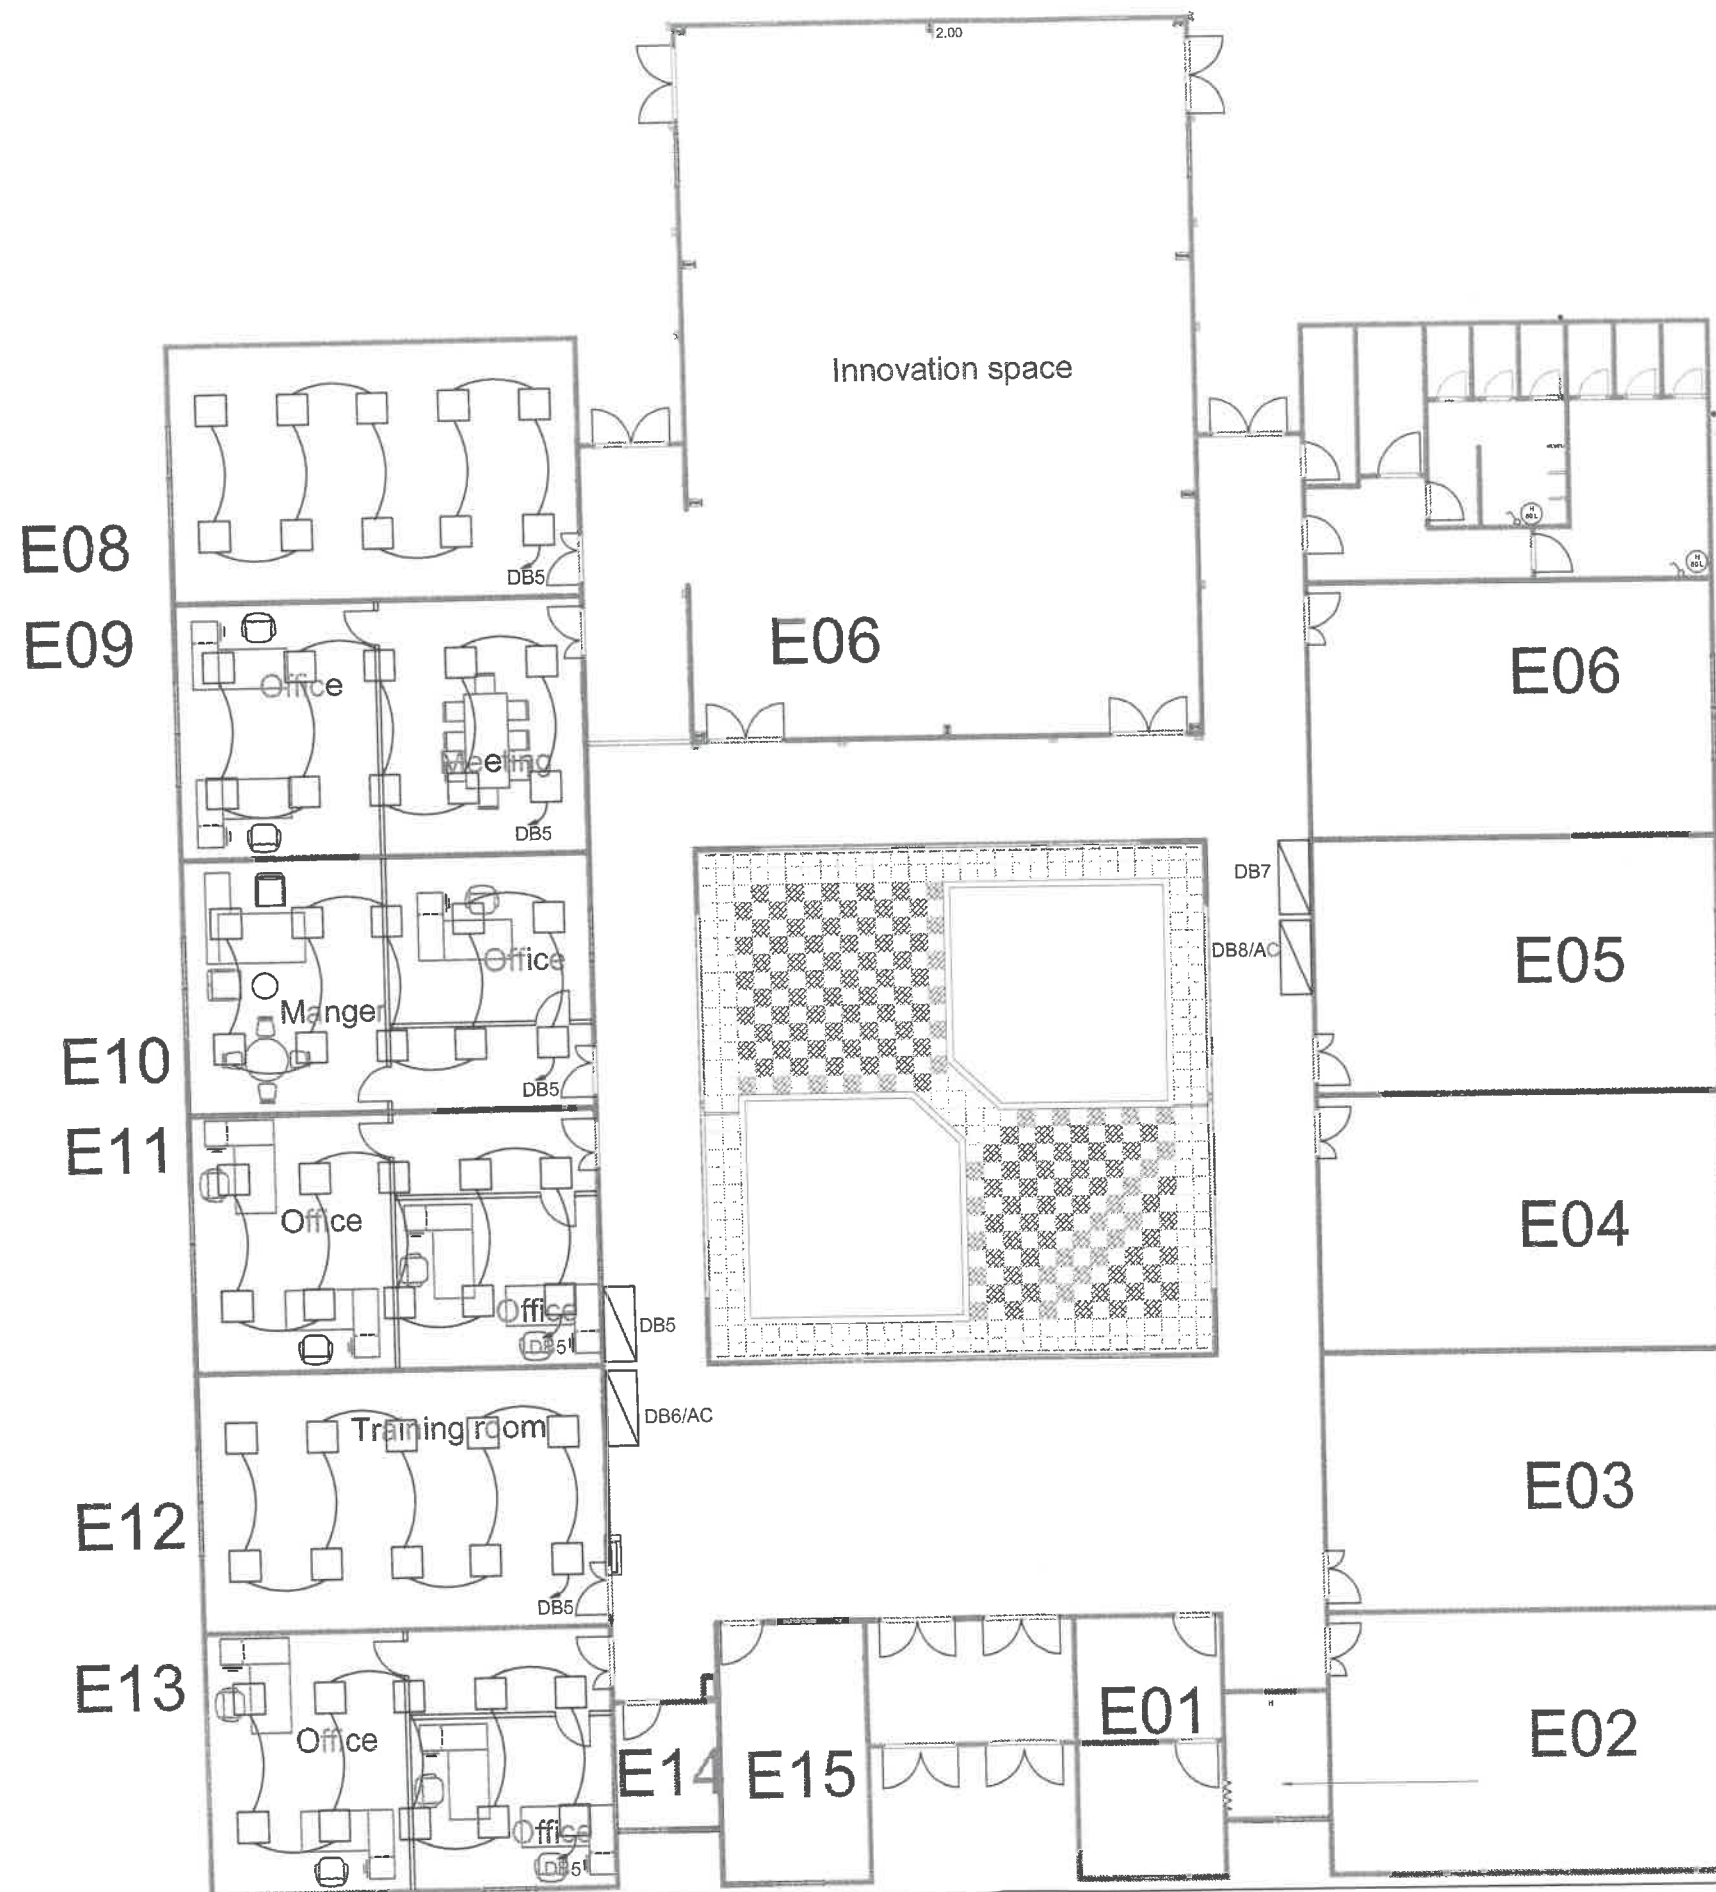

As-Built Drawing Lighting fixtures

PRODUCED BY AN AUTODESK STUDENT VERSION

 PRODUCED BY AN AUTODESK STUDENT VERSION




Client
GJU
 الجامعة الألمانية الأردنية
 German Jordanian University

Consultant
 German Jordanian University
 AMMAN - JORDAN

PREFAB E

Scale
N.T.S

E02

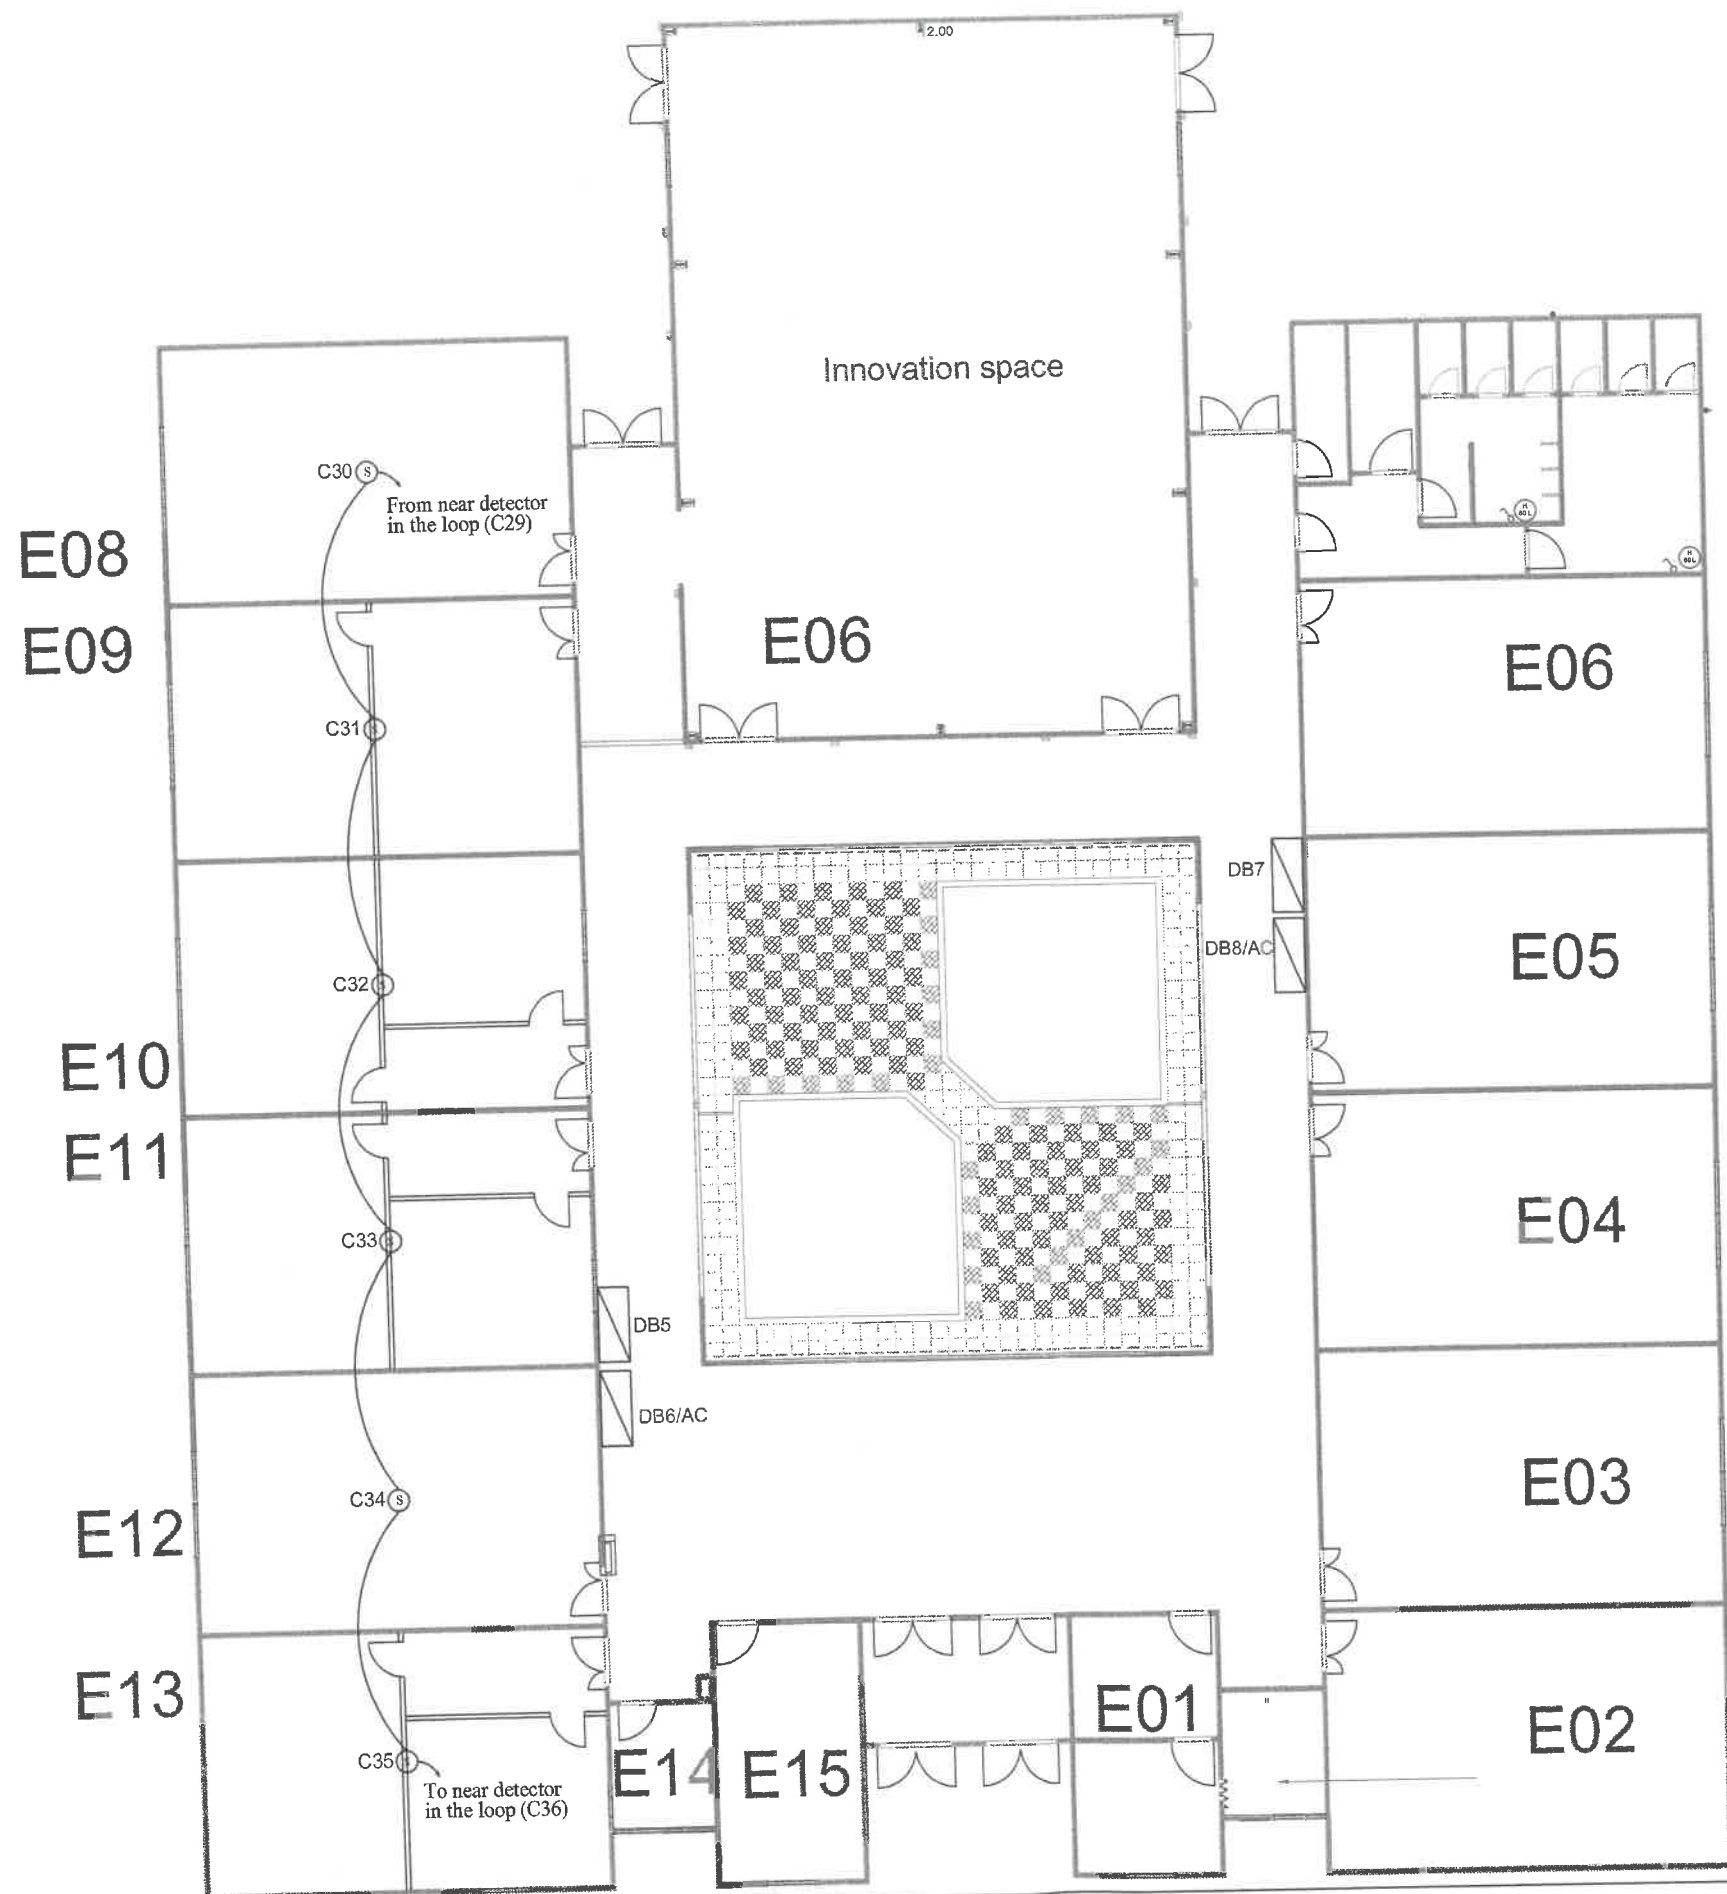


As-built Drawing Fire Alarm system

PRODUCED BY AN AUTODESK STUDENT VERSION


PRODUCED BY AN AUTODESK STUDENT VERSION

KEY PLAN	Client	Consultant
		German Jordanian University
	AMMAN - JORDAN	

PREFAB E	Scale	E03
	N.T.S	

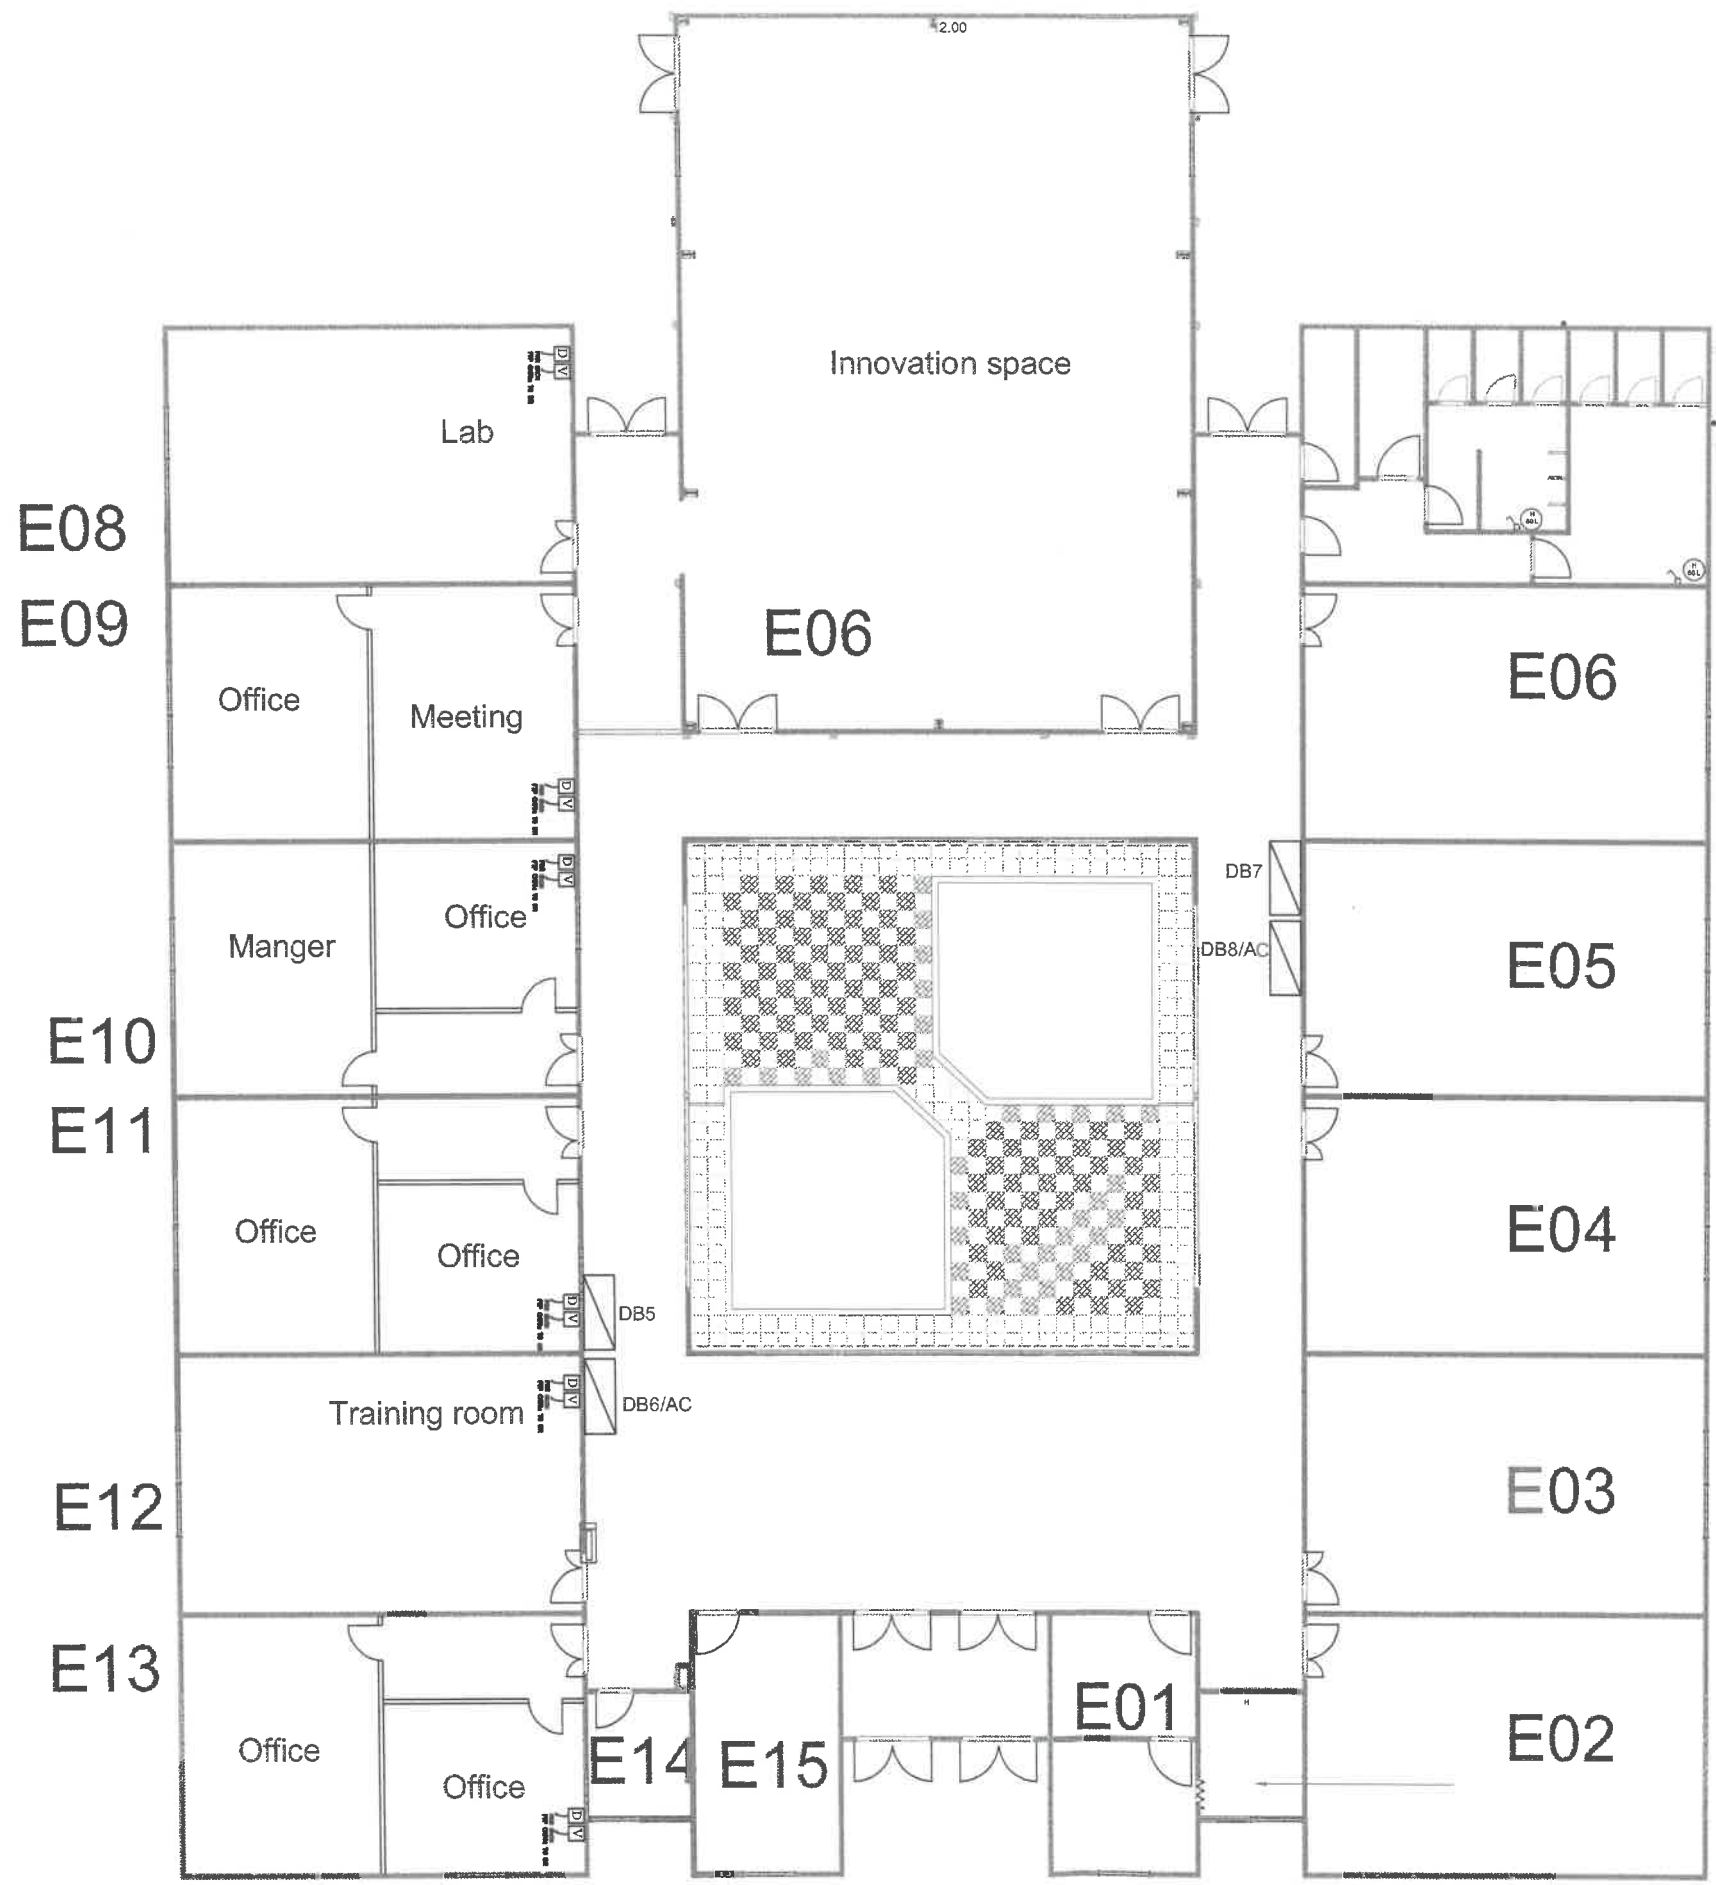


As-built Drawing Data and Voice system

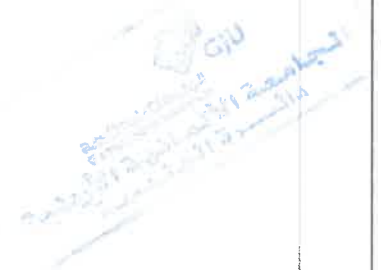

PRODUCED BY AN AUTODESK STUDENT VERSION

PRODUCED BY AN AUTODESK STUDENT VERSION

<p>KEY PLAN</p> 	<p>Client</p>  <p>الجامعة الألمانية الأردنية German Jordanian University</p>	<p>Consultant</p> <p>German Jordanian University AMMAN - JORDAN</p>	<p>PREFAB E</p>	<p>Scale</p> <p>N.T.S</p>	<p>E04</p>
---	---	---	-----------------	---------------------------	------------

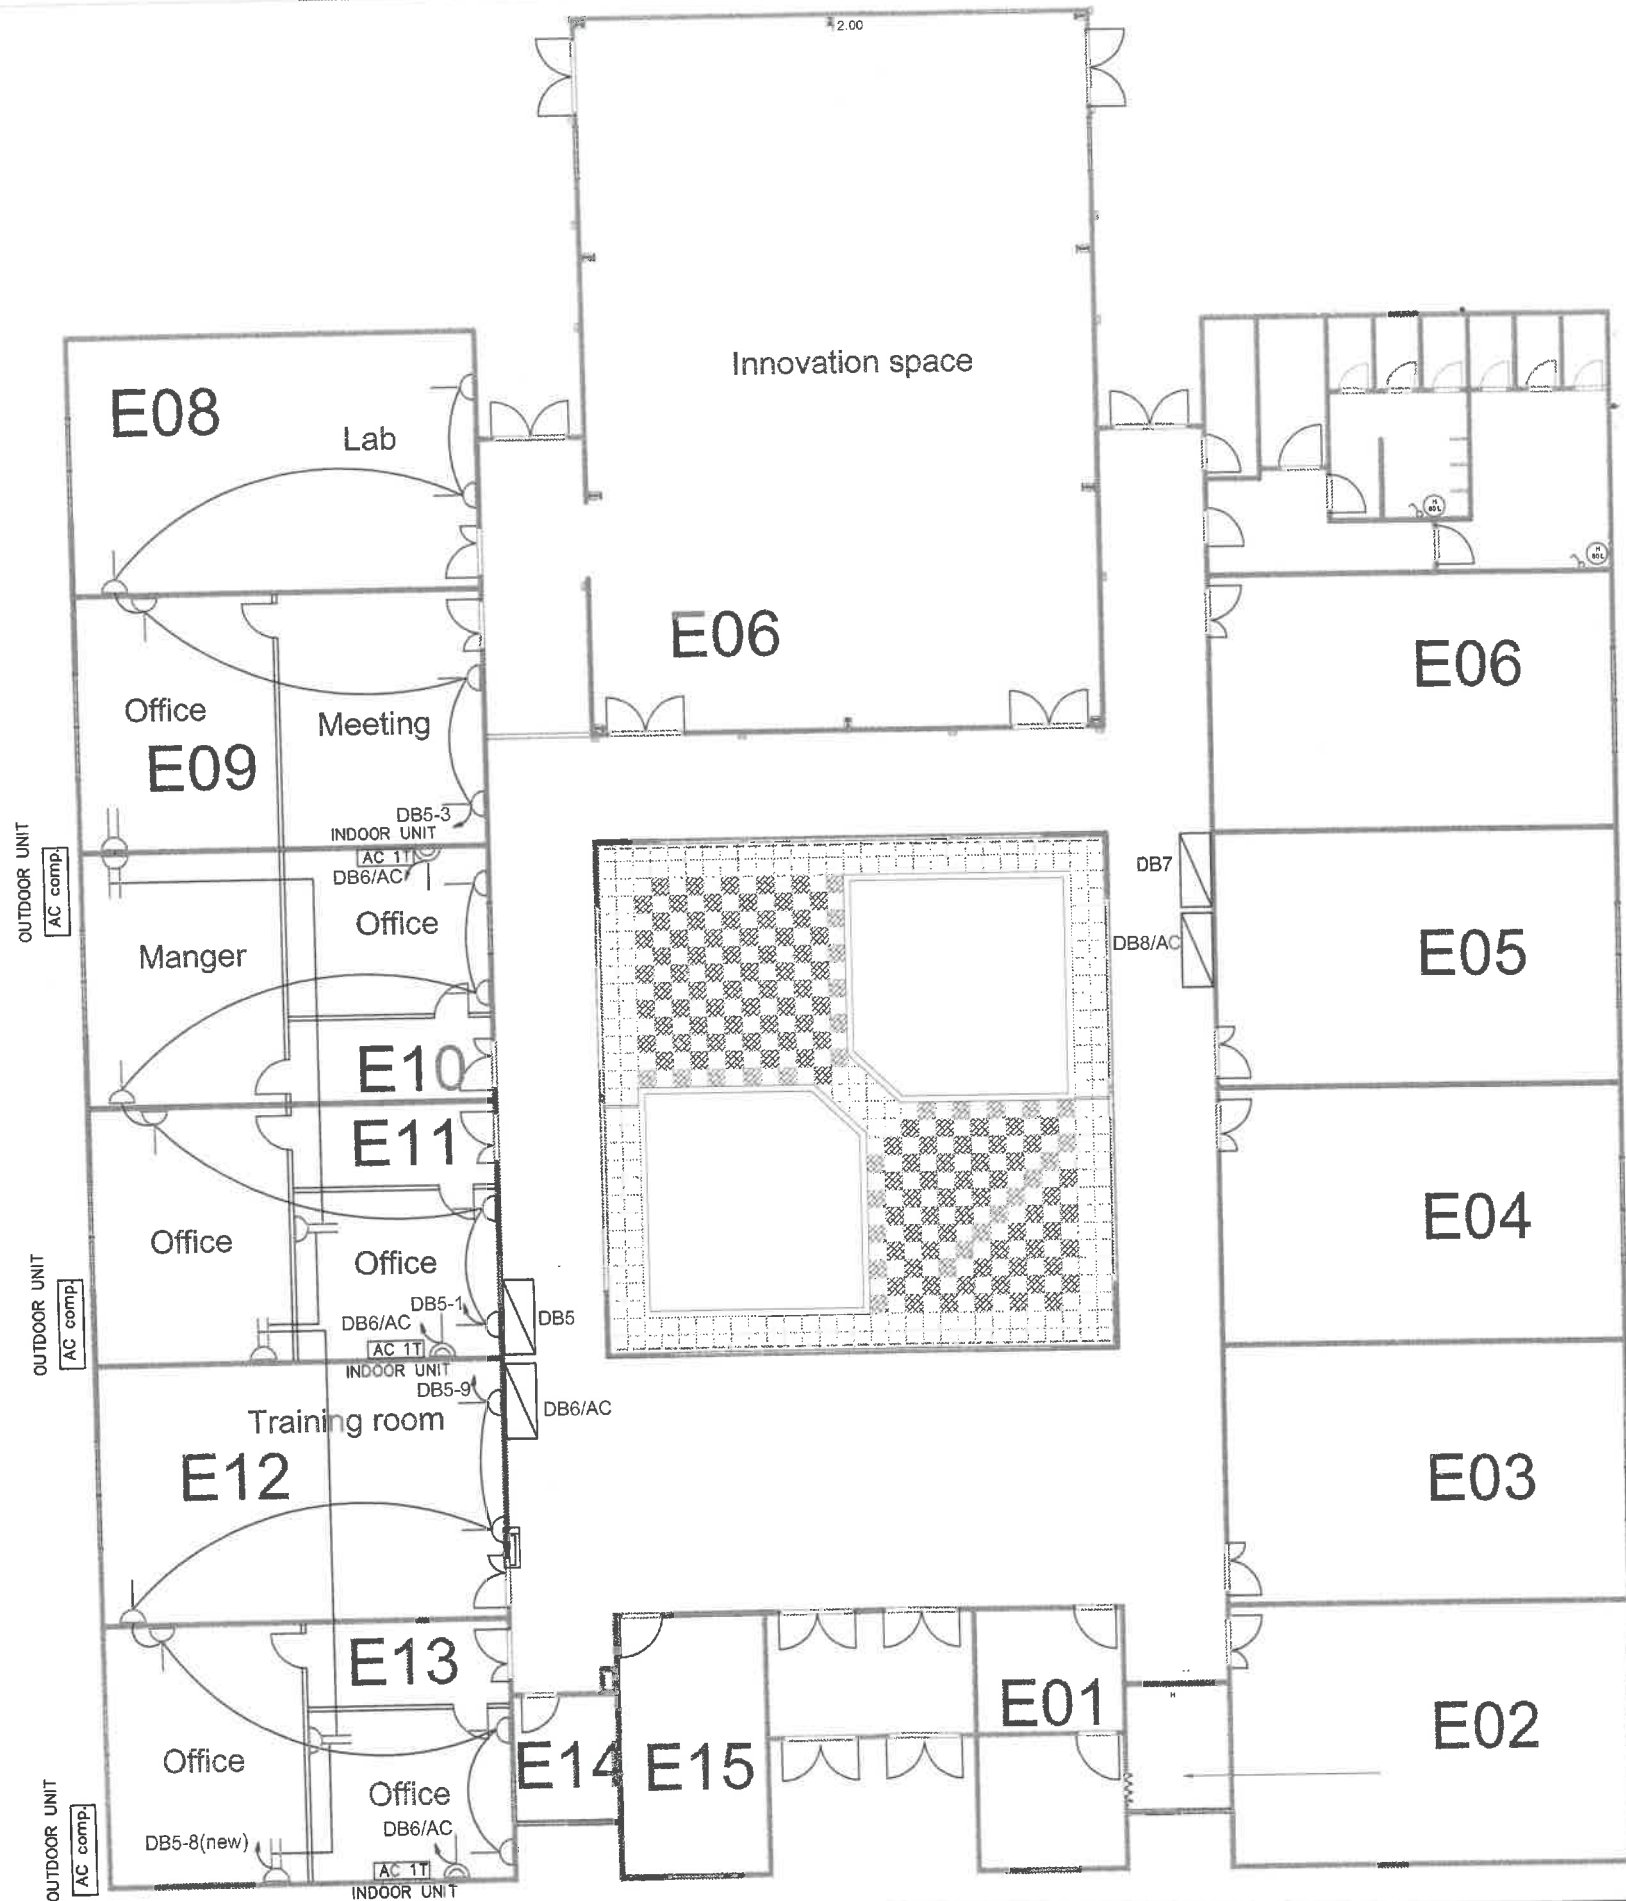

Drawing with additional sockets




Client
GJU
 German Jordanian University
 الجامعة الألمانية الأردنية
 AMMAN - JORDAN

Consultant
 German Jordanian University

PREFAB E

Scale
N.T.S

E05

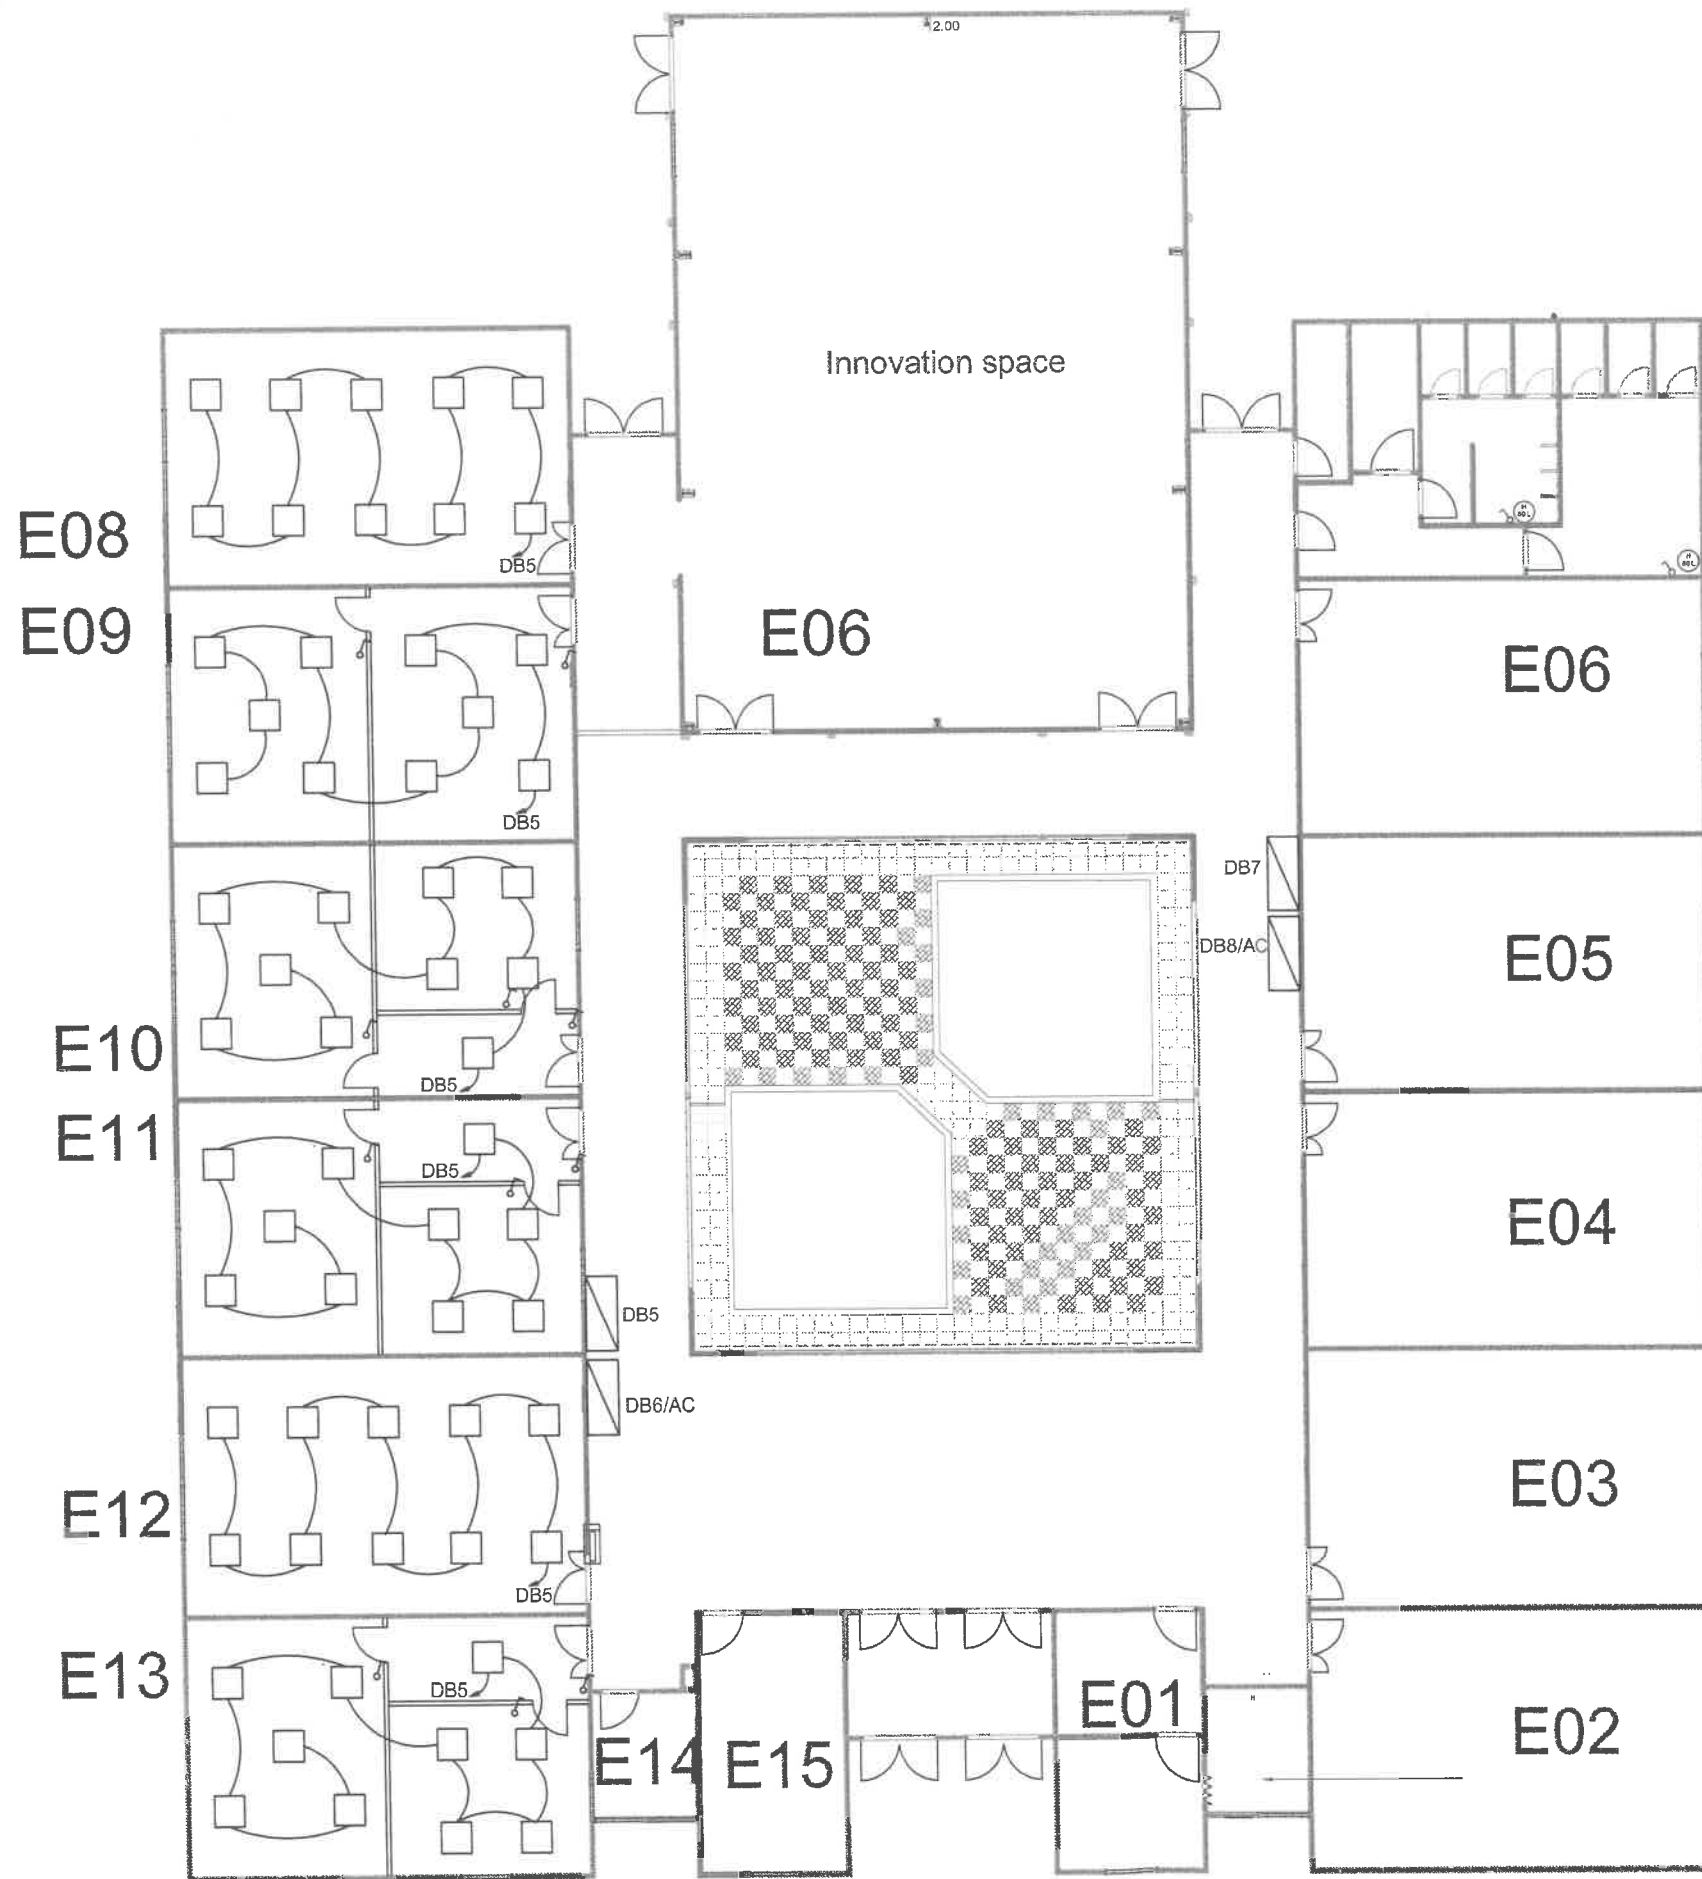

Redesign lighting fixture




Client
GJU
 الجامعة الألمانية الأردنية
 German Jordanian University
 AMMAN - JORDAN

Consultant
 German Jordanian
 University
 AMMAN - JORDAN

PREFAB E

Scale
N.T.S

E06

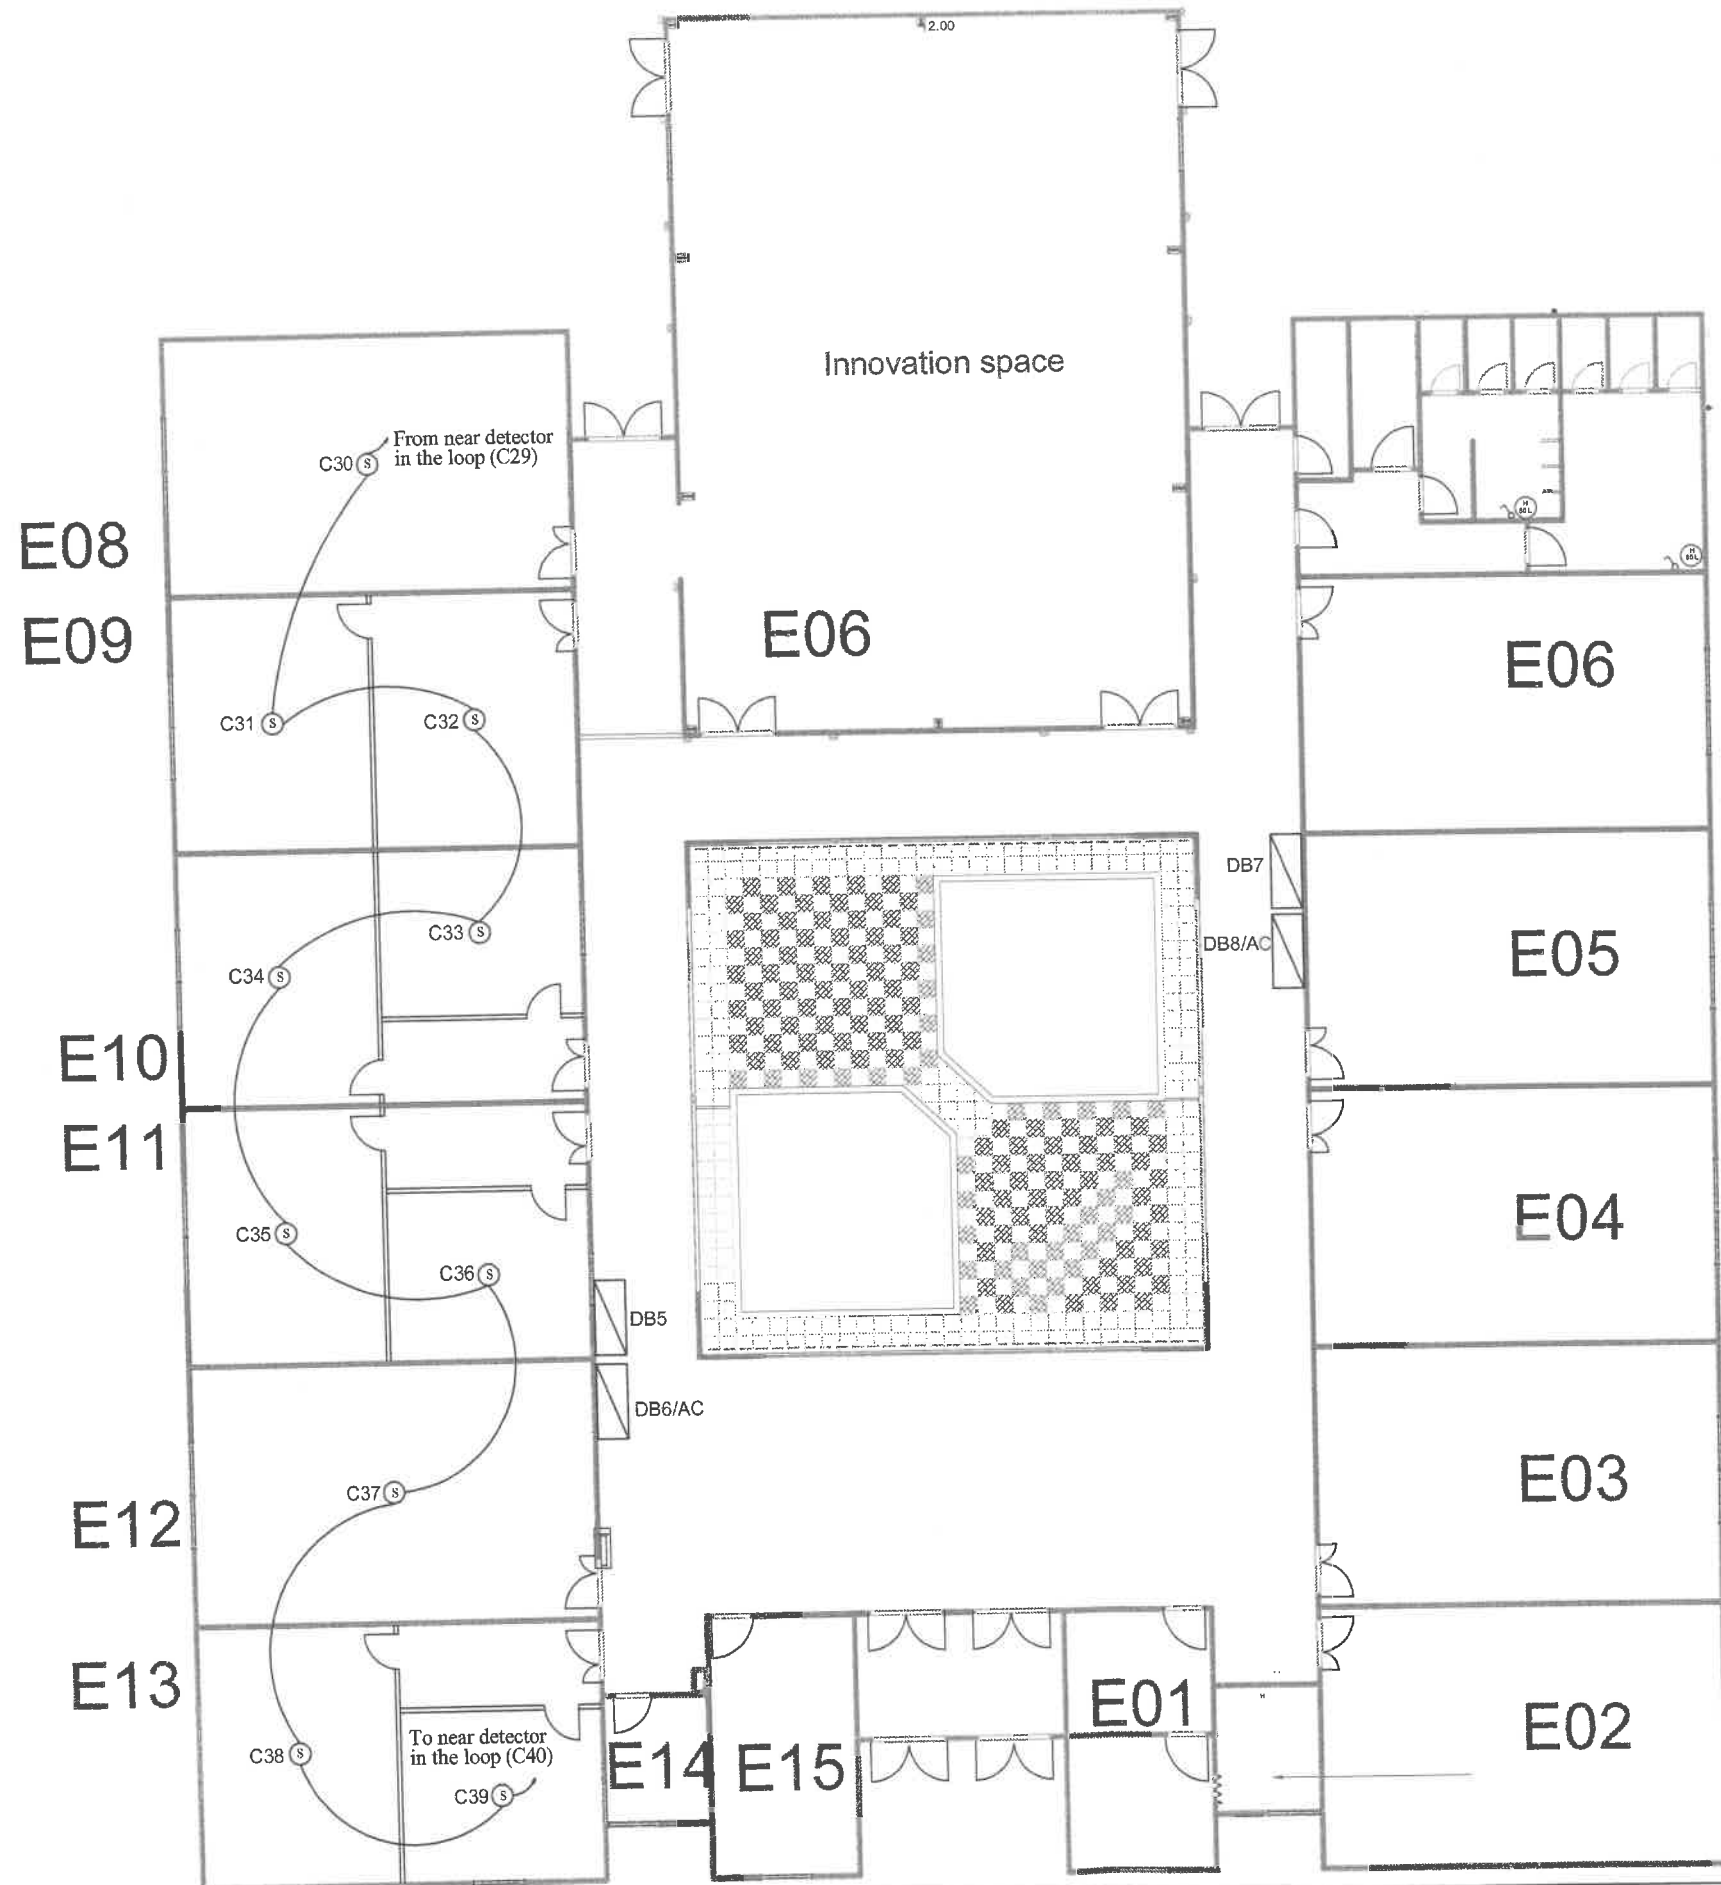

Drawing with additional detectors

PRODUCED BY AN AUTODESK STUDENT VERSION


PRODUCED BY AN AUTODESK STUDENT VERSION



Client
GJU
 الجامعة الألمانية الأردنية
 German Jordanian University
 AMMAN - JORDAN

Consultant
 German Jordanian
 University
 AMMAN - JORDAN

PREFAB E	Scale N.T.S	E07
----------	----------------	-----

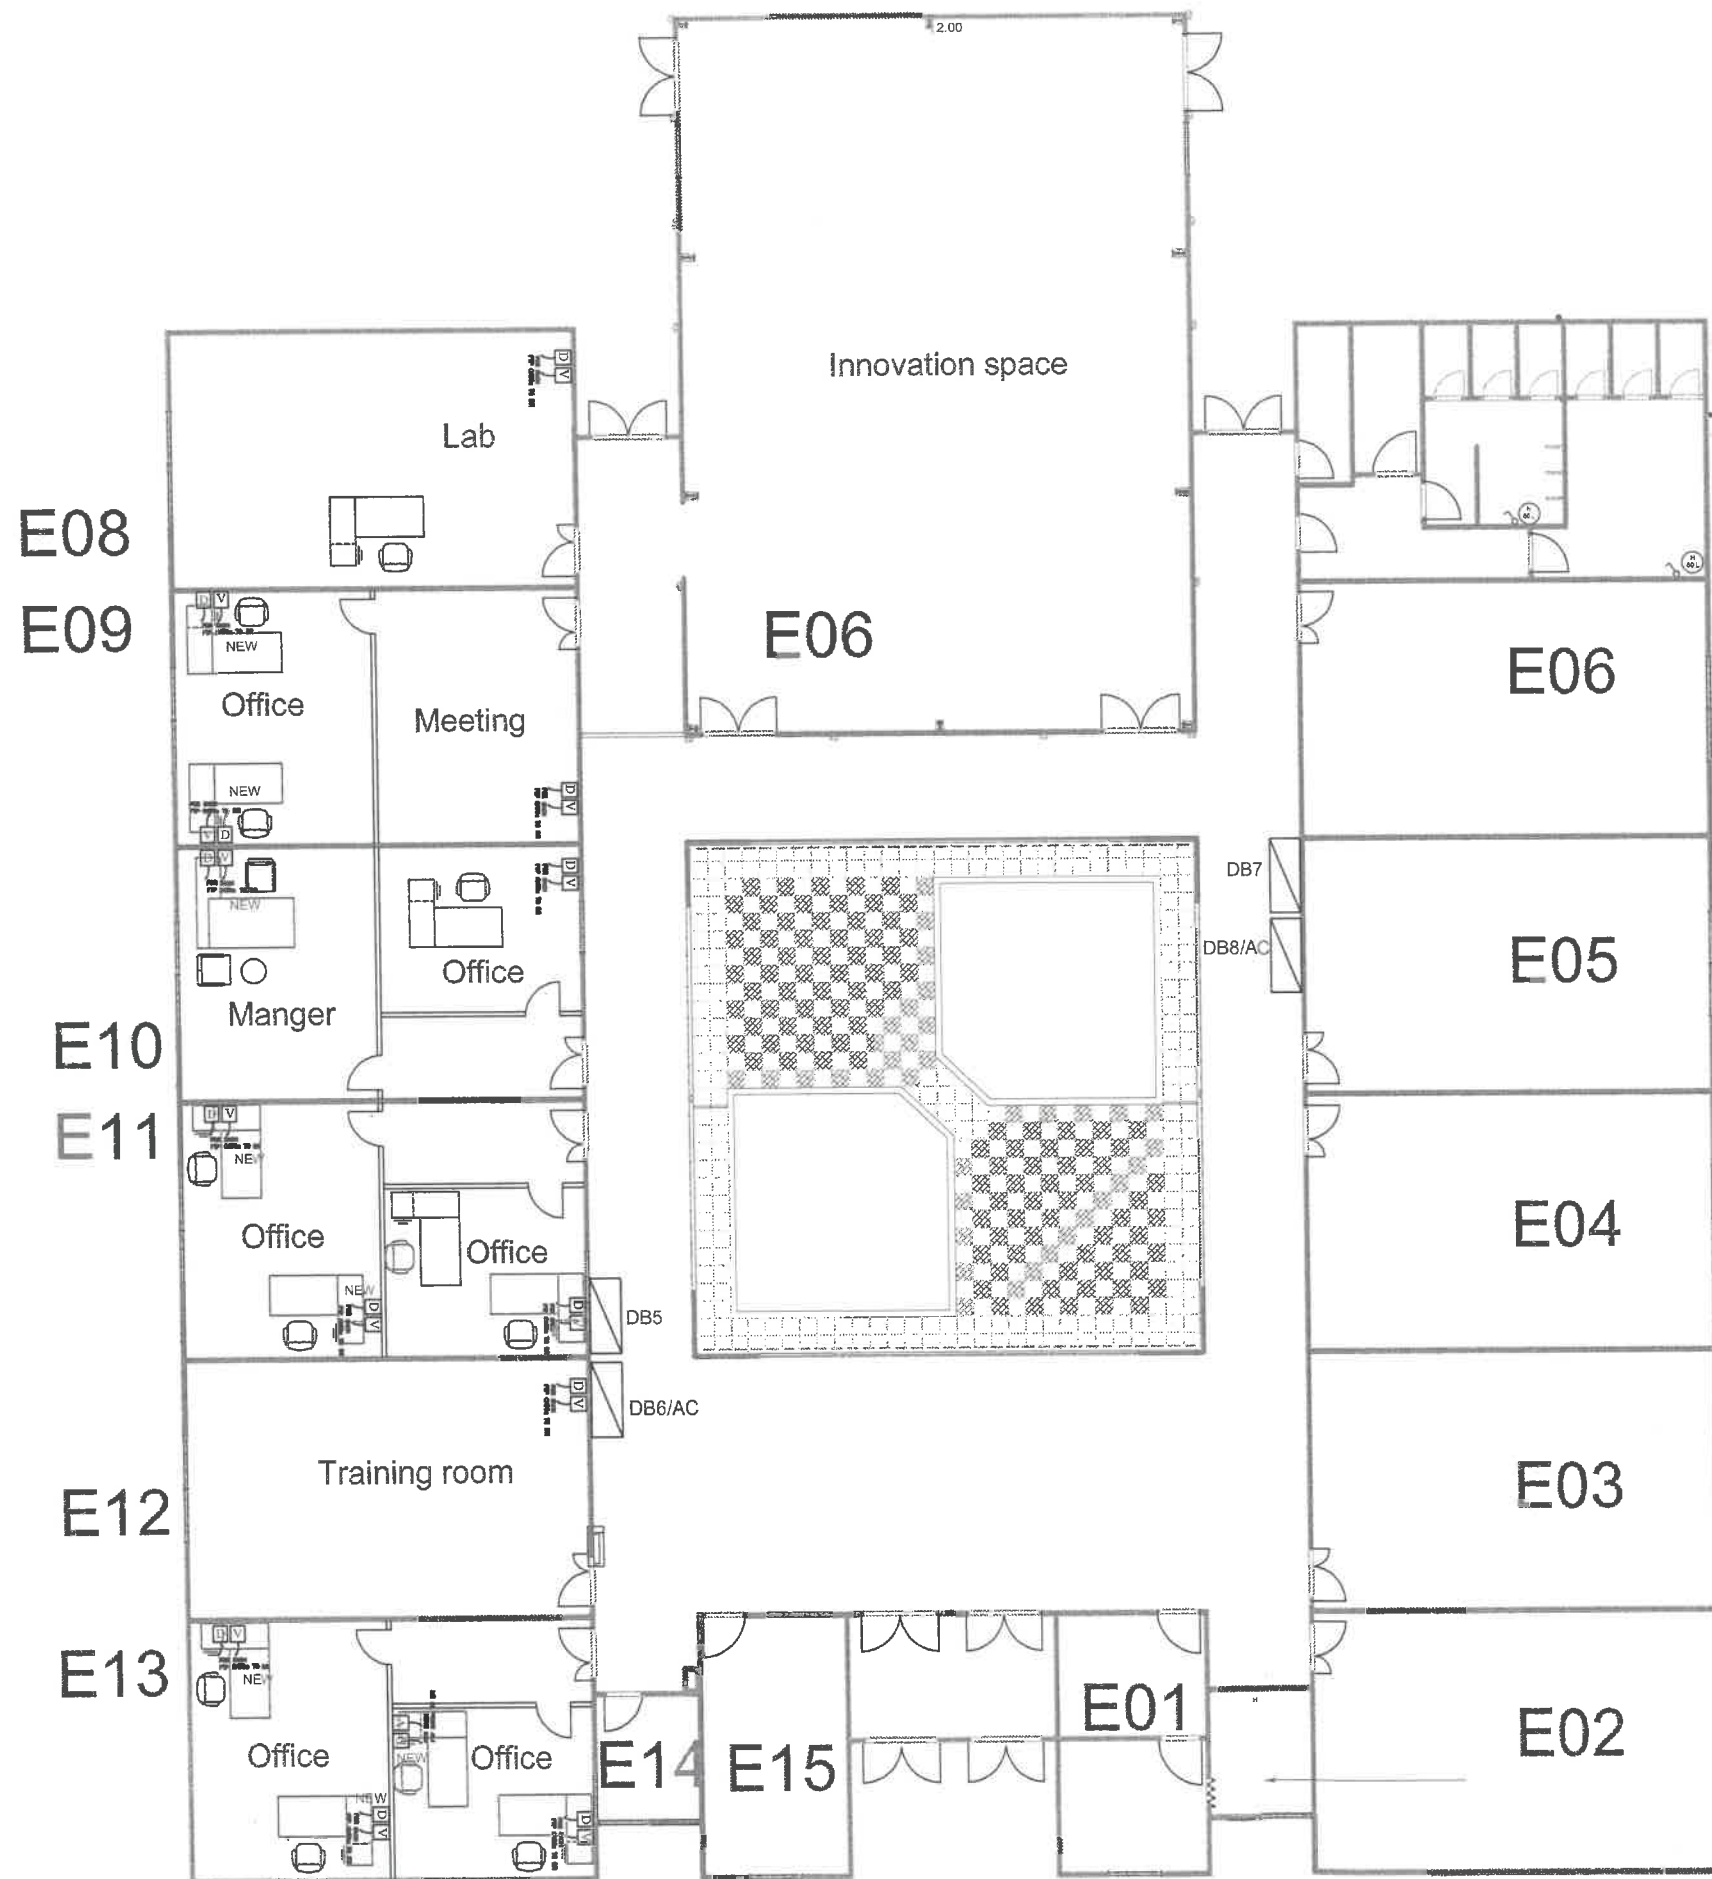

Drawing with additional data and voice sockets

PRODUCED BY AN AUTODESK STUDENT VERSION

PRODUCED BY AN AUTODESK STUDENT VERSION




Client
GJU
 الجامعة الألمانية الأردنية
 German Jordanian University
 AMMAN - JORDAN

Consultant
 German Jordanian
 University
 AMMAN - JORDAN

PREFAB E

Scale
N.T.S

E08

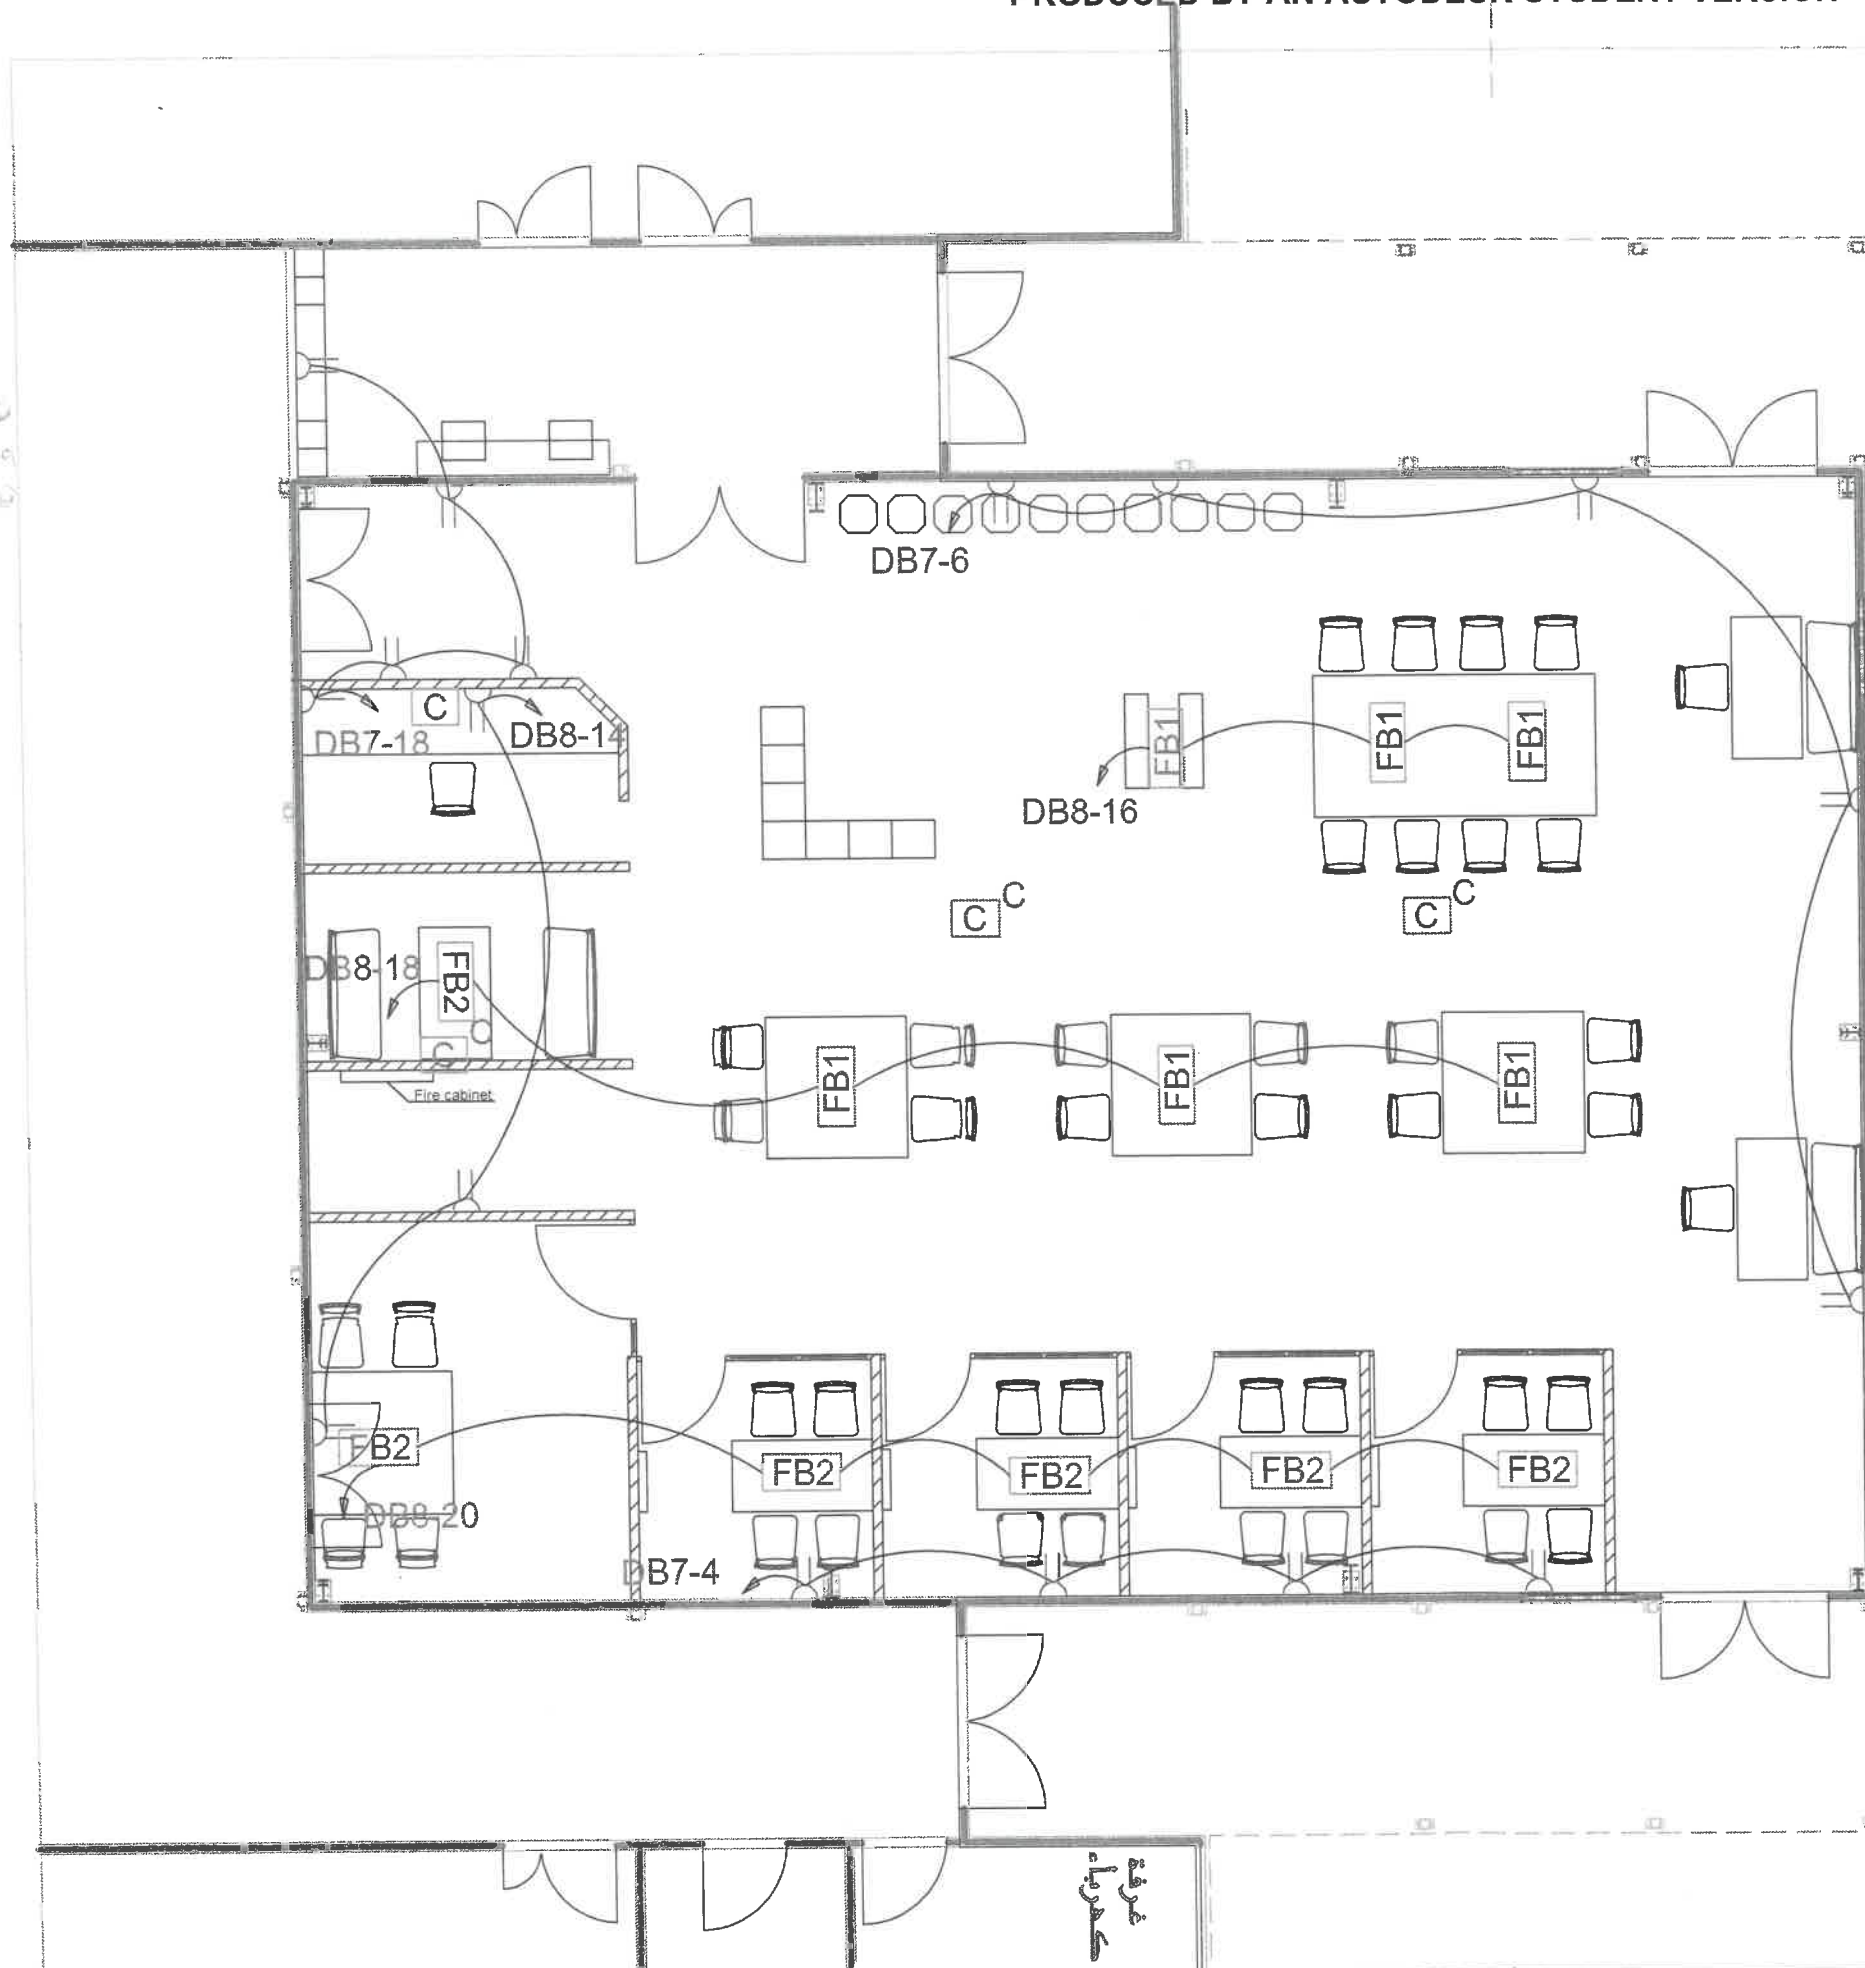

LEGEND :

- 3 PIN, 230 V, 13A SWITCH SOCKET OUTLET
- 3 PIN, 230 V, 13A SWITCH SOCKET DOUBLEX
- FB** Floor Data Point
 - FB1
 - FB2
- C** Ceiling Data Point



Client
GU
 الجامعة الألمانية الأردنية
 German Jordanian University
 AMMAN - JORDAN

Consultant
 German Jordanian University
 AMMAN - JORDAN

PREFAB E
 Innovation space

Scale
 N.T.S

E09



LEGEND :

- Led Recessed Modular Light 75W, 9750 Lm, IP 44
- Led Recessed Modular Light 36W, 4680 Lm, IP 44
- Decorative suspended LED light

KEY PLAN 	Client الجامعة الألمانية الأردنية German Jordanian University	Consultant German Jordanian University AMMAN - JORDAN
--------------	---	---

PREFAB E Innovation space	Scale N.T.S	E10
------------------------------	----------------	-----